

GENERAL NOTES

1. USE THESE DOCUMENTS IN CONJUNCTION WITH THE STANDARD DESIGN GUIDE AND INTERACTIVE PROGRAMMING WORKSHEET

DRAWING LIST

NUMBER	NAME
C-1	COVER SHEET
A-1	STANDARD DESIGN PLAN
A-2	MODULES A, B, & C PLANS & AXONS
A-3	MODULES D,E & F PLANS & AXONS

AIR FORCE STANDARD DESIGN CES FACILITY MAINTENANCE BUILDING



PHASE: PRE-FINAL SUBMITTAL
DATE: MARCH 2018
SCALE: AS INDICATED

**AIR FORCE
CIVIL ENGINEER
CENTER**

CIVIL ENGINEER SQUADRON:
FACILITY MAINTENANCE
ANY AFB, CONUS
COVER SHEET

SHEET
NUMBER
C-1


MARCH 2018

NOT FOR CONSTRUCTION

MODULE TYPE LEGEND

- A-FACILITY MAINTENANCE
- B-TOOL STORAGE
- C-ADMINISTRATION
- D-BREAK ROOM
- E-LOCKER, TOILET, SHOWER, JANITOR
- F-BUILDING SUPPORT
- CIRCULATION

THIS BASIS OF DESIGN CONCEPT FLOOR PLAN IS BASED ON THE APPROVED FUNCTIONAL ADJACENCY DIAGRAM. THE ROOM CRITERIA IS LOCATED IN THE ROOM DATA SHEETS IN THE STANDARD DESIGN DOCUMENT AND THE ROOM SIZES ARE LOCATED IN THE INTERACTIVE PROGRAMMING WORKSHEET. THE OVERALL DIMENSIONS ARE APPROXIMATE AS THE BASIS OF DESIGN CONCEPT PLAN DOES NOT INDICATE STRUCTURAL ELEMENTS, ALL PLUMBING CHASES, MISCELLANEOUS UTILITY ROOMS (MECHANICAL, ELECTRICAL, COMMUNICATIONS) OR WALL THICKNESSES, ETC.

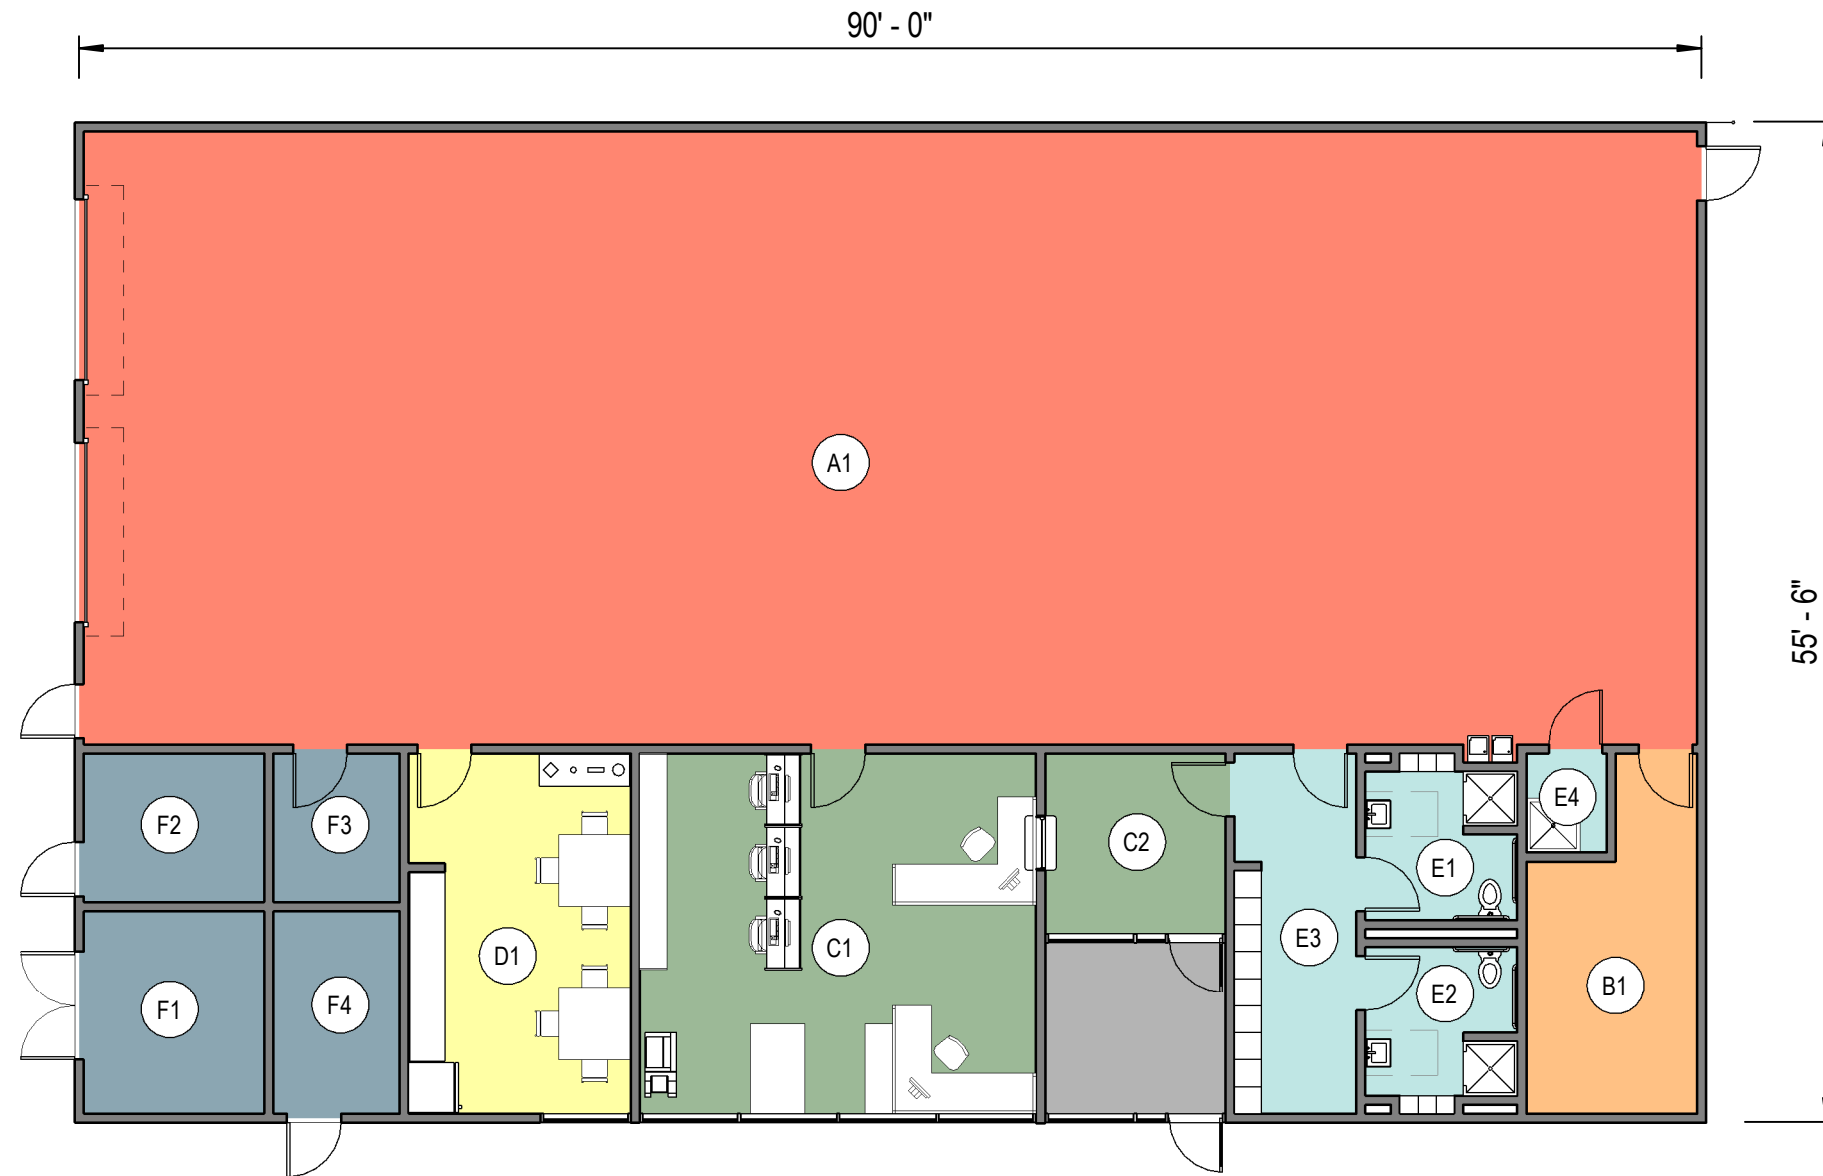


PHASE:	PRE-FINAL SUBMITTAL
DATE:	MARCH 2018
SCALE:	AS INDICATED

**AIR FORCE
CIVIL ENGINEER
CENTER**

CIVIL ENGINEER SQUADRON:
FACILITY MAINTENANCE
ANY AFB, CONUS
**STANDARD DESIGN
PLAN**

SHEET
NUMBER
A-1

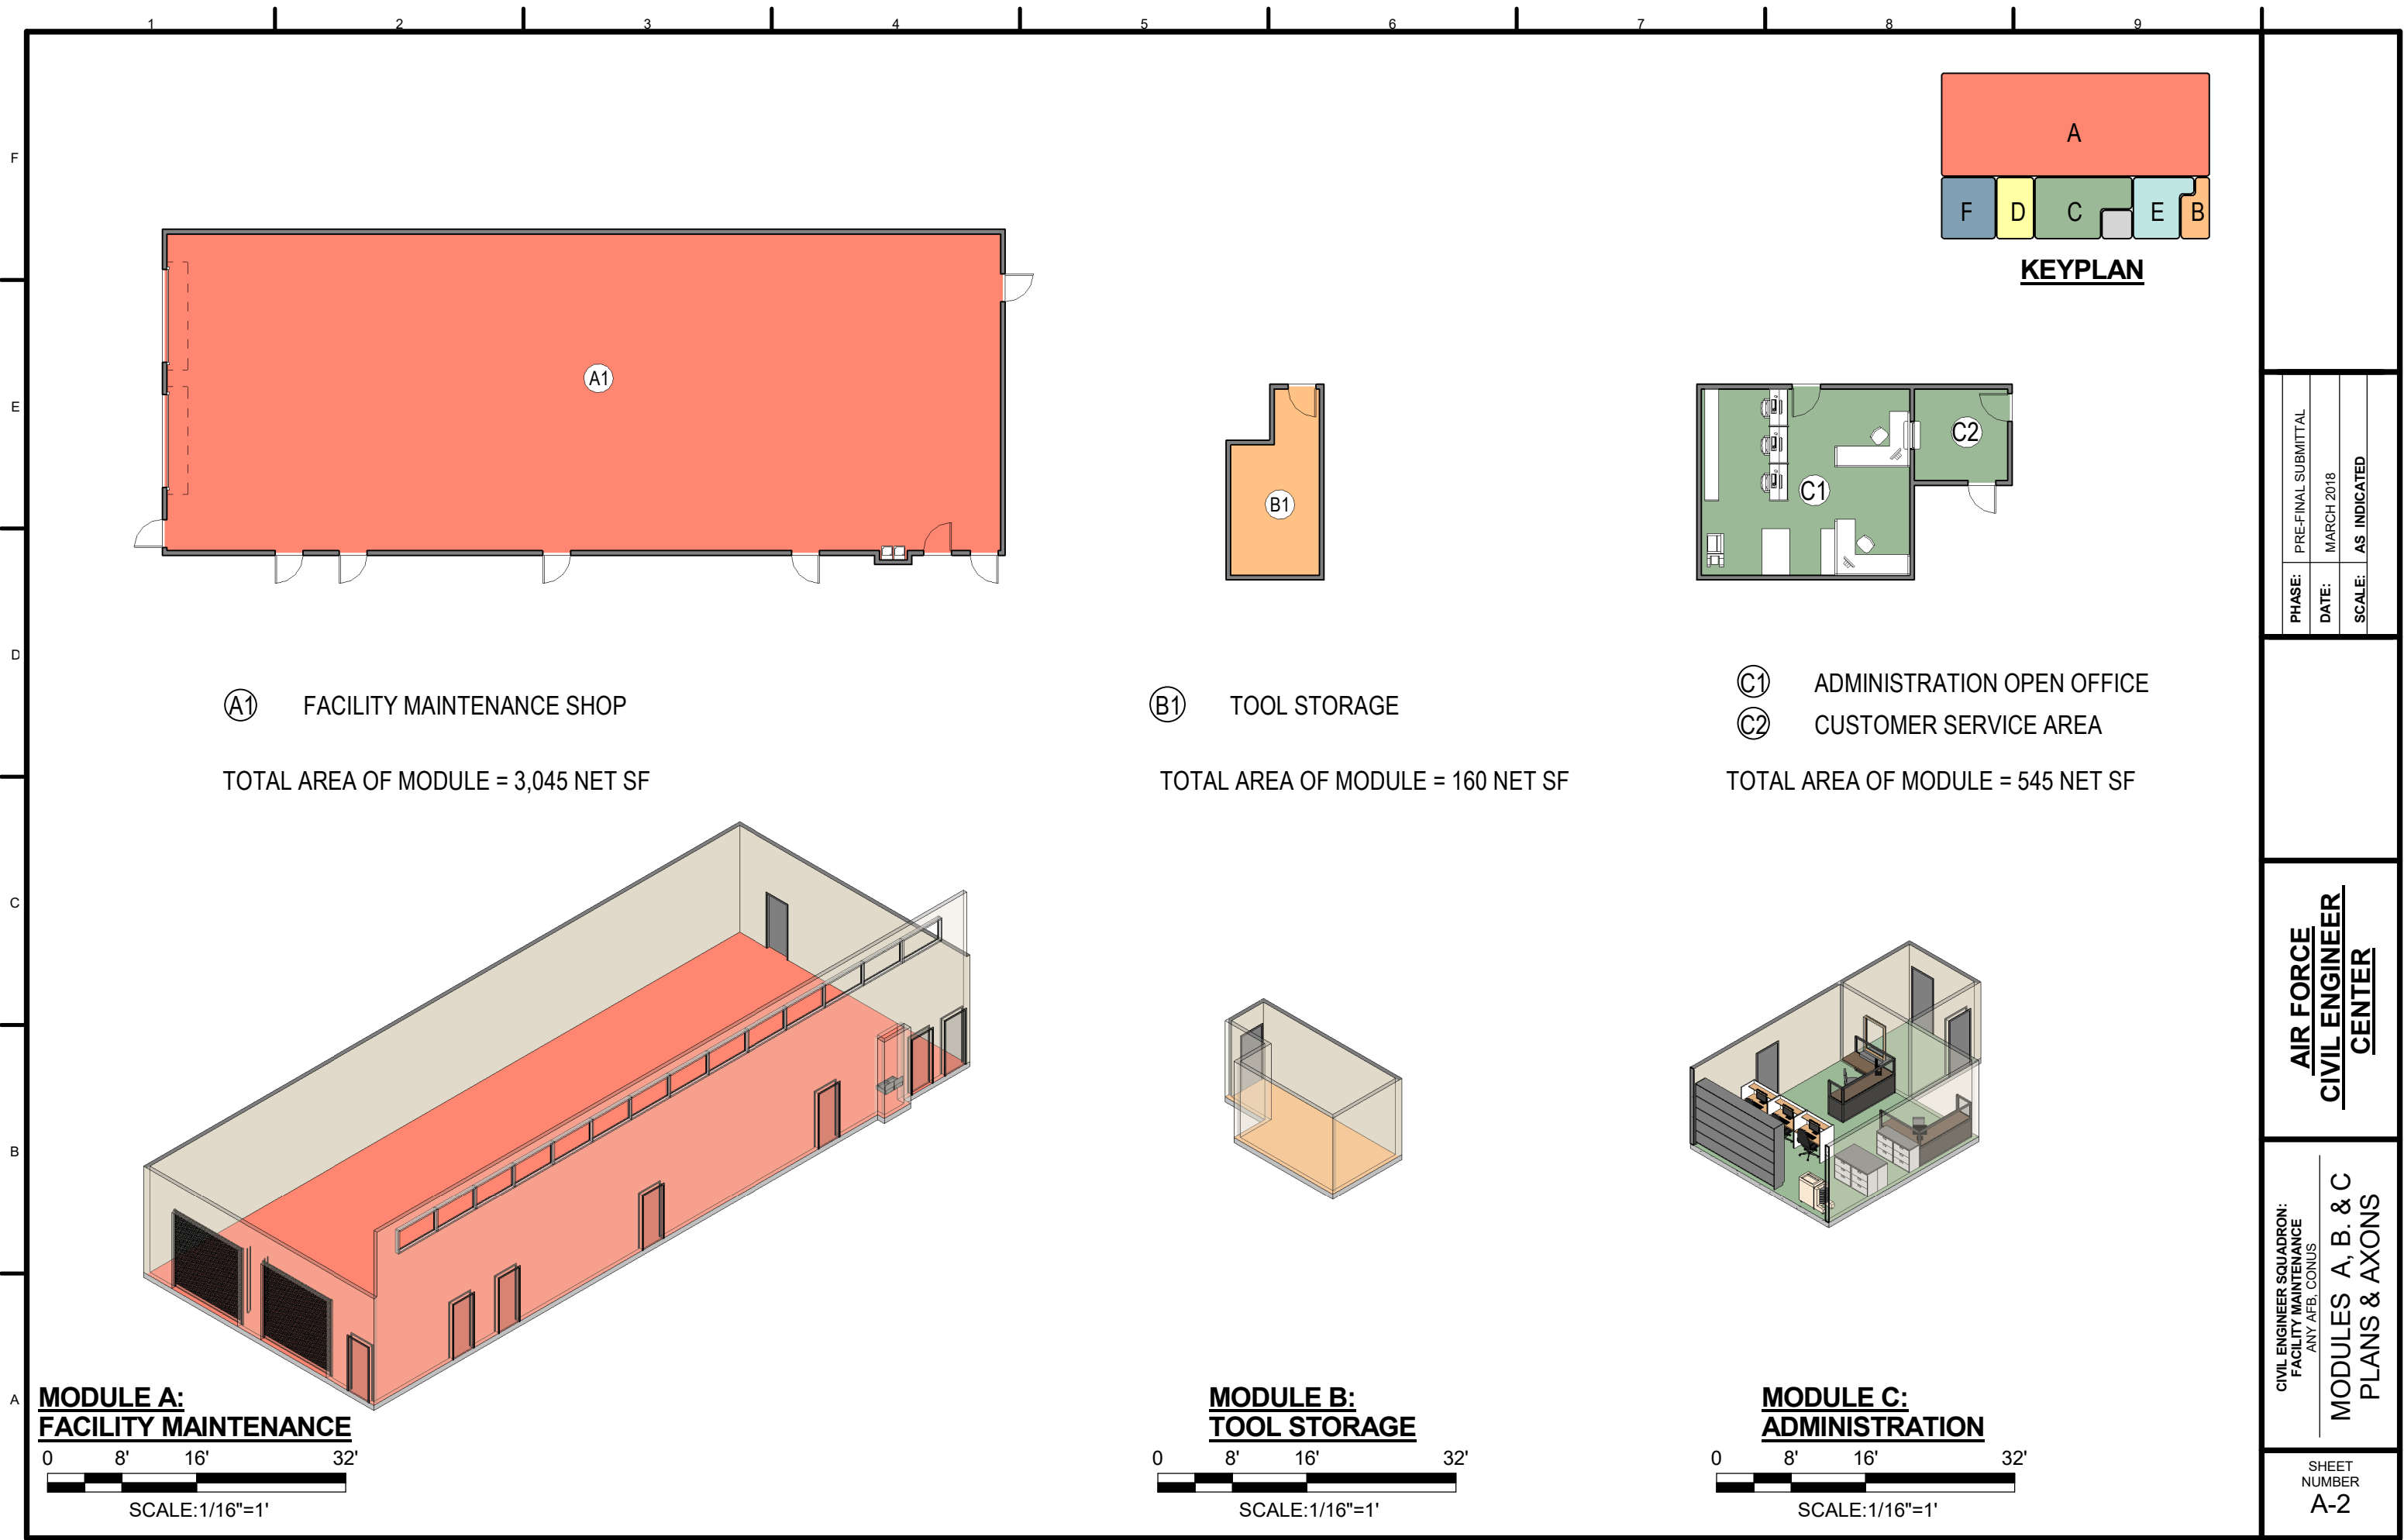

Ⓐ FACILITY MAINTENANCE SHOP

TOTAL AREA OF MODULE = 3,045 NET SF

**MODULE A:
FACILITY MAINTENANCE**



Ⓑ TOOL STORAGE

TOTAL AREA OF MODULE = 160 NET SF

**MODULE B:
TOOL STORAGE**



Ⓒ ADMINISTRATION OPEN OFFICE
Ⓓ CUSTOMER SERVICE AREA

TOTAL AREA OF MODULE = 545 NET SF

**MODULE C:
ADMINISTRATION**




KEYPLAN

PHASE:	PRE-FINAL SUBMITTAL
DATE:	MARCH 2018
SCALE:	AS INDICATED

**AIR FORCE
CIVIL ENGINEER
CENTER**

CIVIL ENGINEER SQUADRON:
FACILITY MAINTENANCE
ANY AFB, CONUS
**MODULES A, B, & C
PLANS & AXONS**

SHEET
NUMBER
A-2

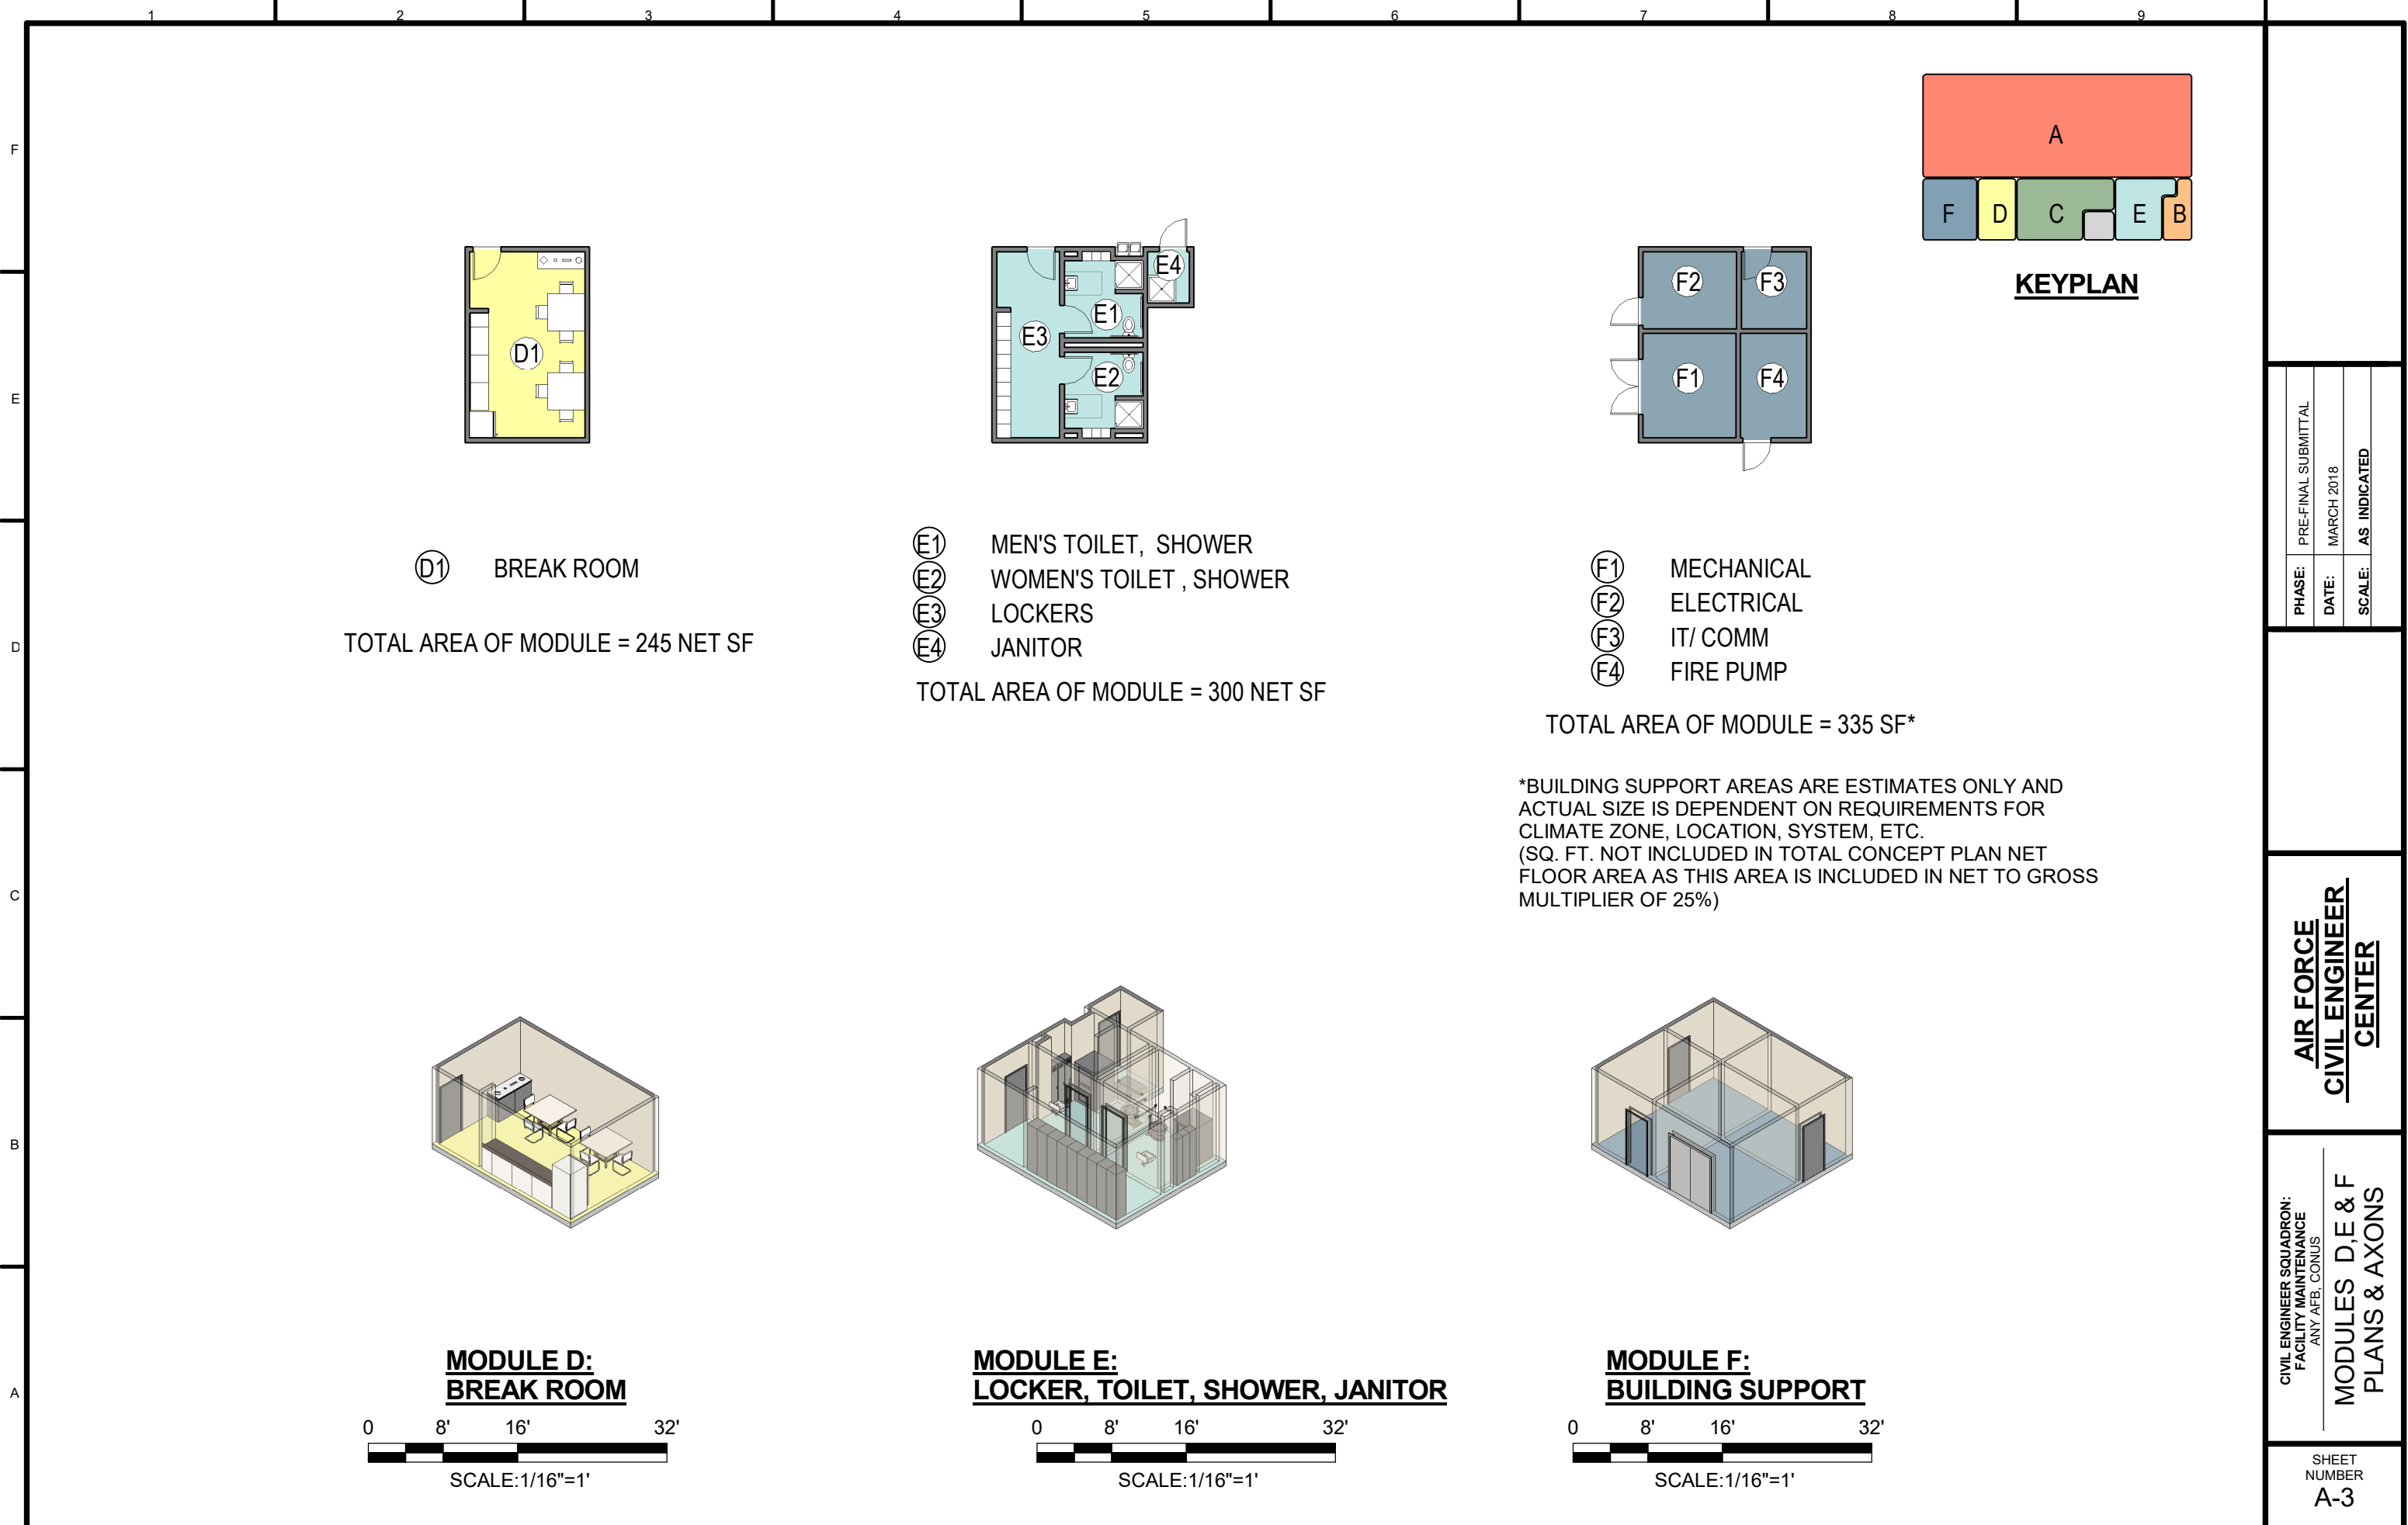

PHASE:	PRE-FINAL SUBMITTAL
DATE:	MARCH 2018
SCALE:	AS INDICATED

**AIR FORCE
 CIVIL ENGINEER
 CENTER**

**CIVIL ENGINEER SQUADRON:
 FACILITY MAINTENANCE
 ANY AFB, CONUS
 MODULES D,E & F
 PLANS & AXONS**

SHEET NUMBER
A-3