

1

2

3

4

5

GENERAL NOTES

- 1. ALL SINGLE STATION SMOKE ALARMS WITHIN EACH DWELLING UNIT MUST BE INTERCONNECTED TO SOUND AT ONCE.
- 2. WALL MOUNTED FIRE ALARM SPEAKERS ARE MOUNTED AT 78" AFF.

JACOBS™

NOT FOR
CONSTRUCTION

911 Central Parkway N., Suite 425 San Antonio, TX 78323
501 North Broadway, St. Louis, Missouri 63102-2121

Revision:
Date: By: Description:

AIR FORCE CENTER FOR ENGINEERING AND THE
ENVIRONMENT (AFCEE)
FACILITIES DYNAMIC PROTOTYPES DESIGN FOR
DORMITORIES

Scales: 1/4" = 1'-0"

Jacobs Project No.: FDWD1301

Drawing Title:

FIRE ALARM
PLANS/AXON

Date: May 11, 2009


Designed By: Designer

Drawn By: SBW

Checked By: Checker


Drawing No.:

FA101

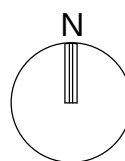

D


C

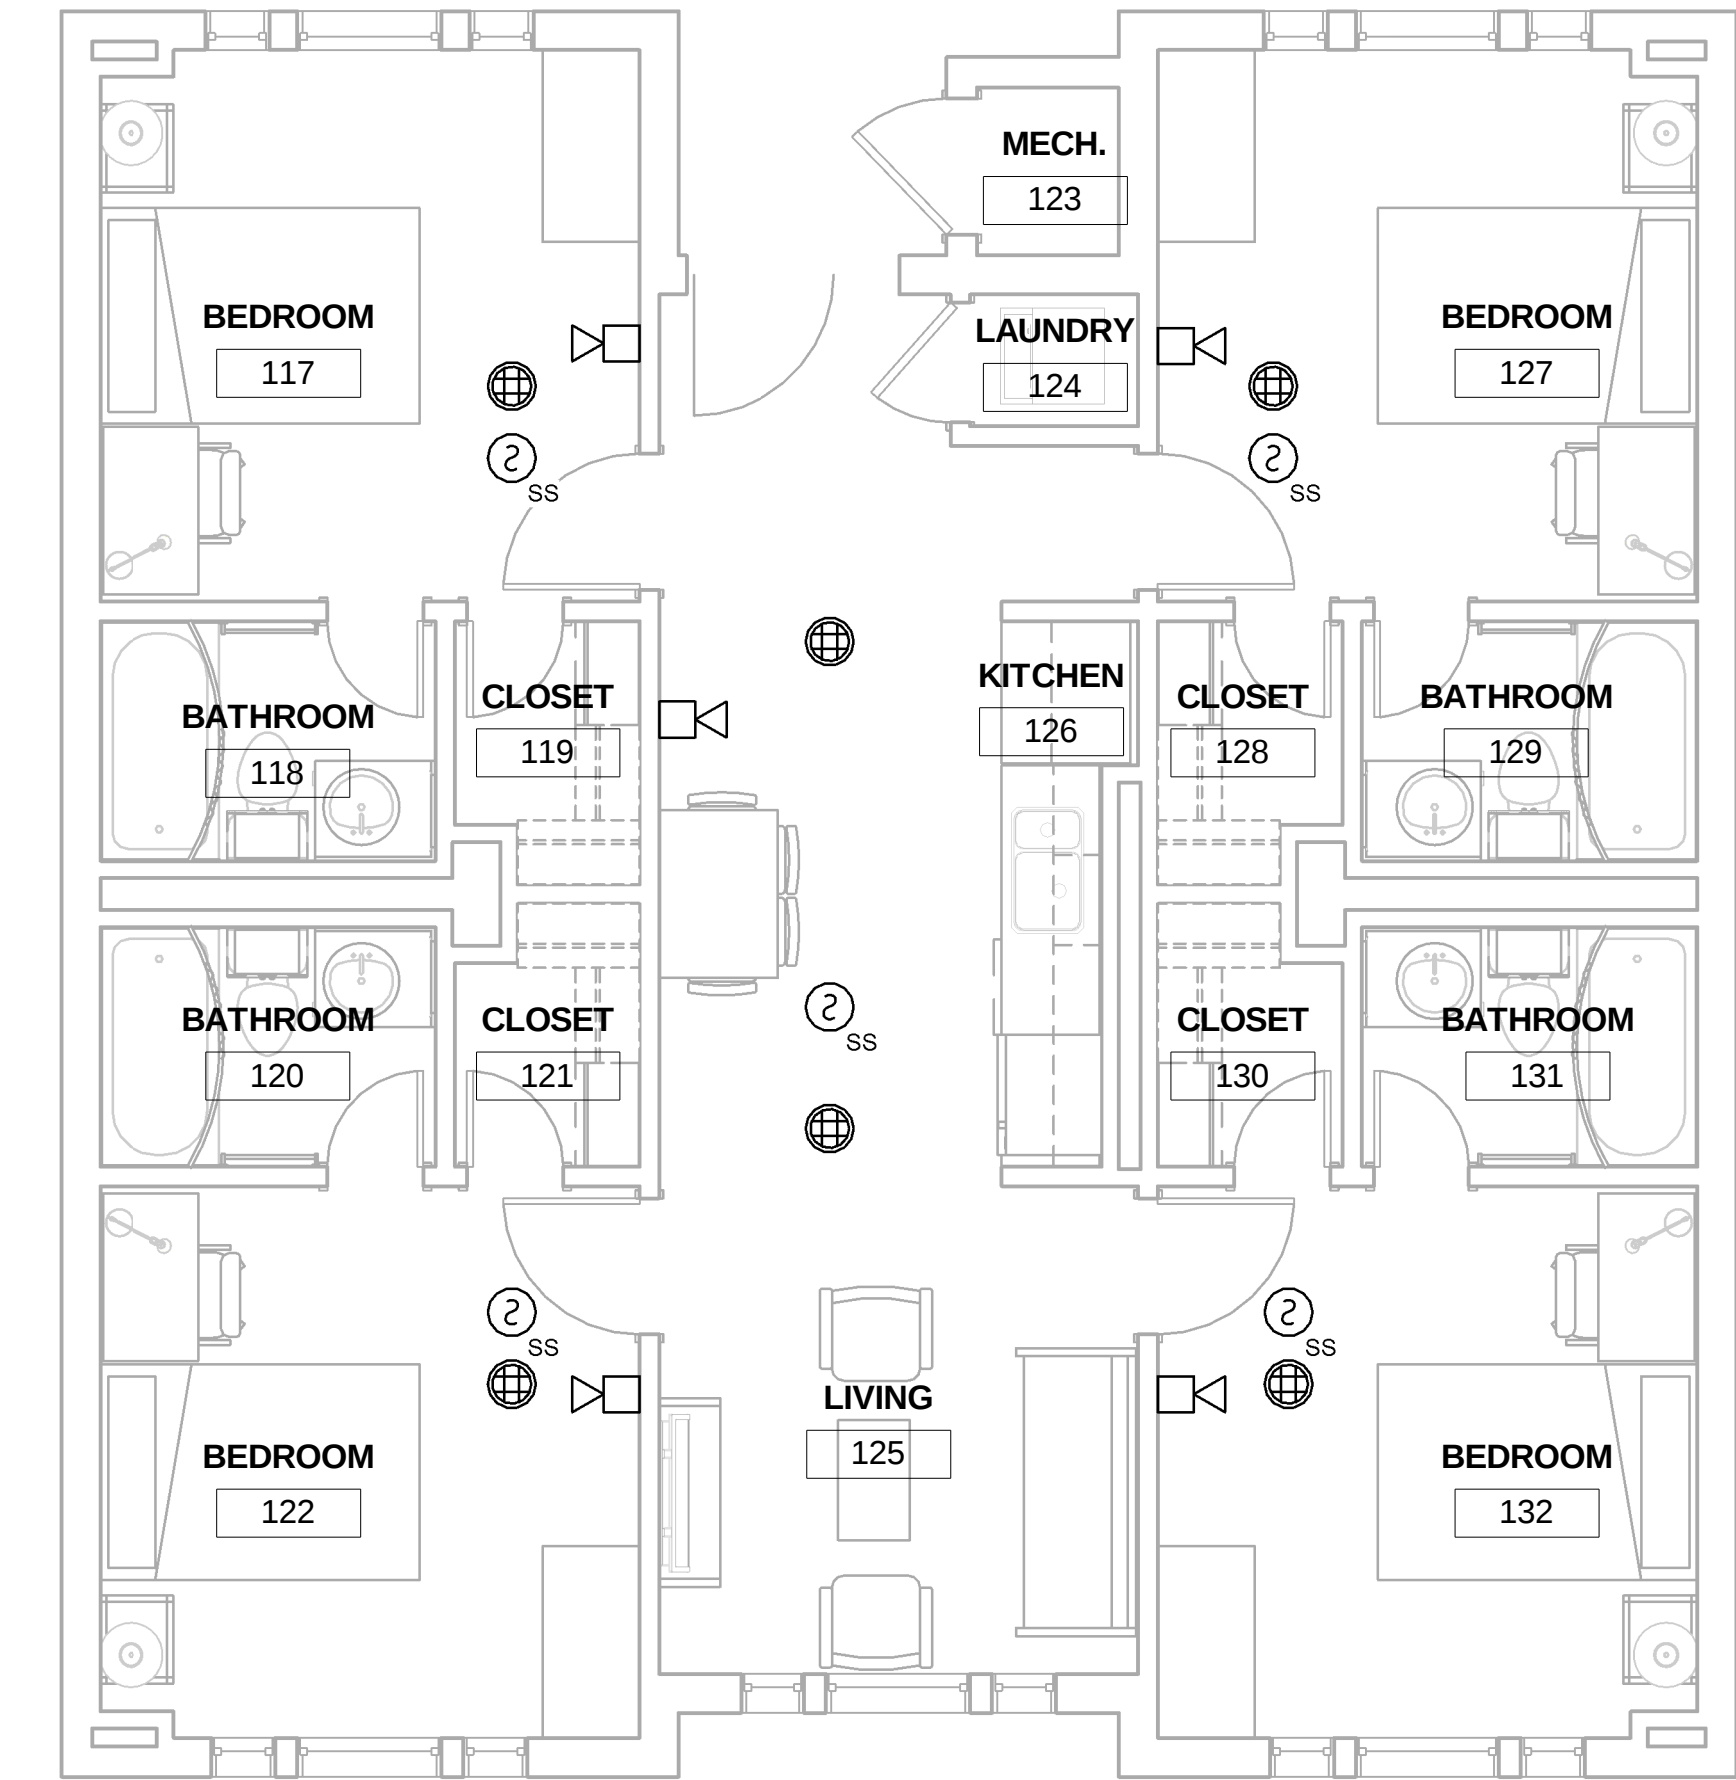


C1 PLAN B FIRE ALARM PLAN
1/4" = 1'-0"

B


A

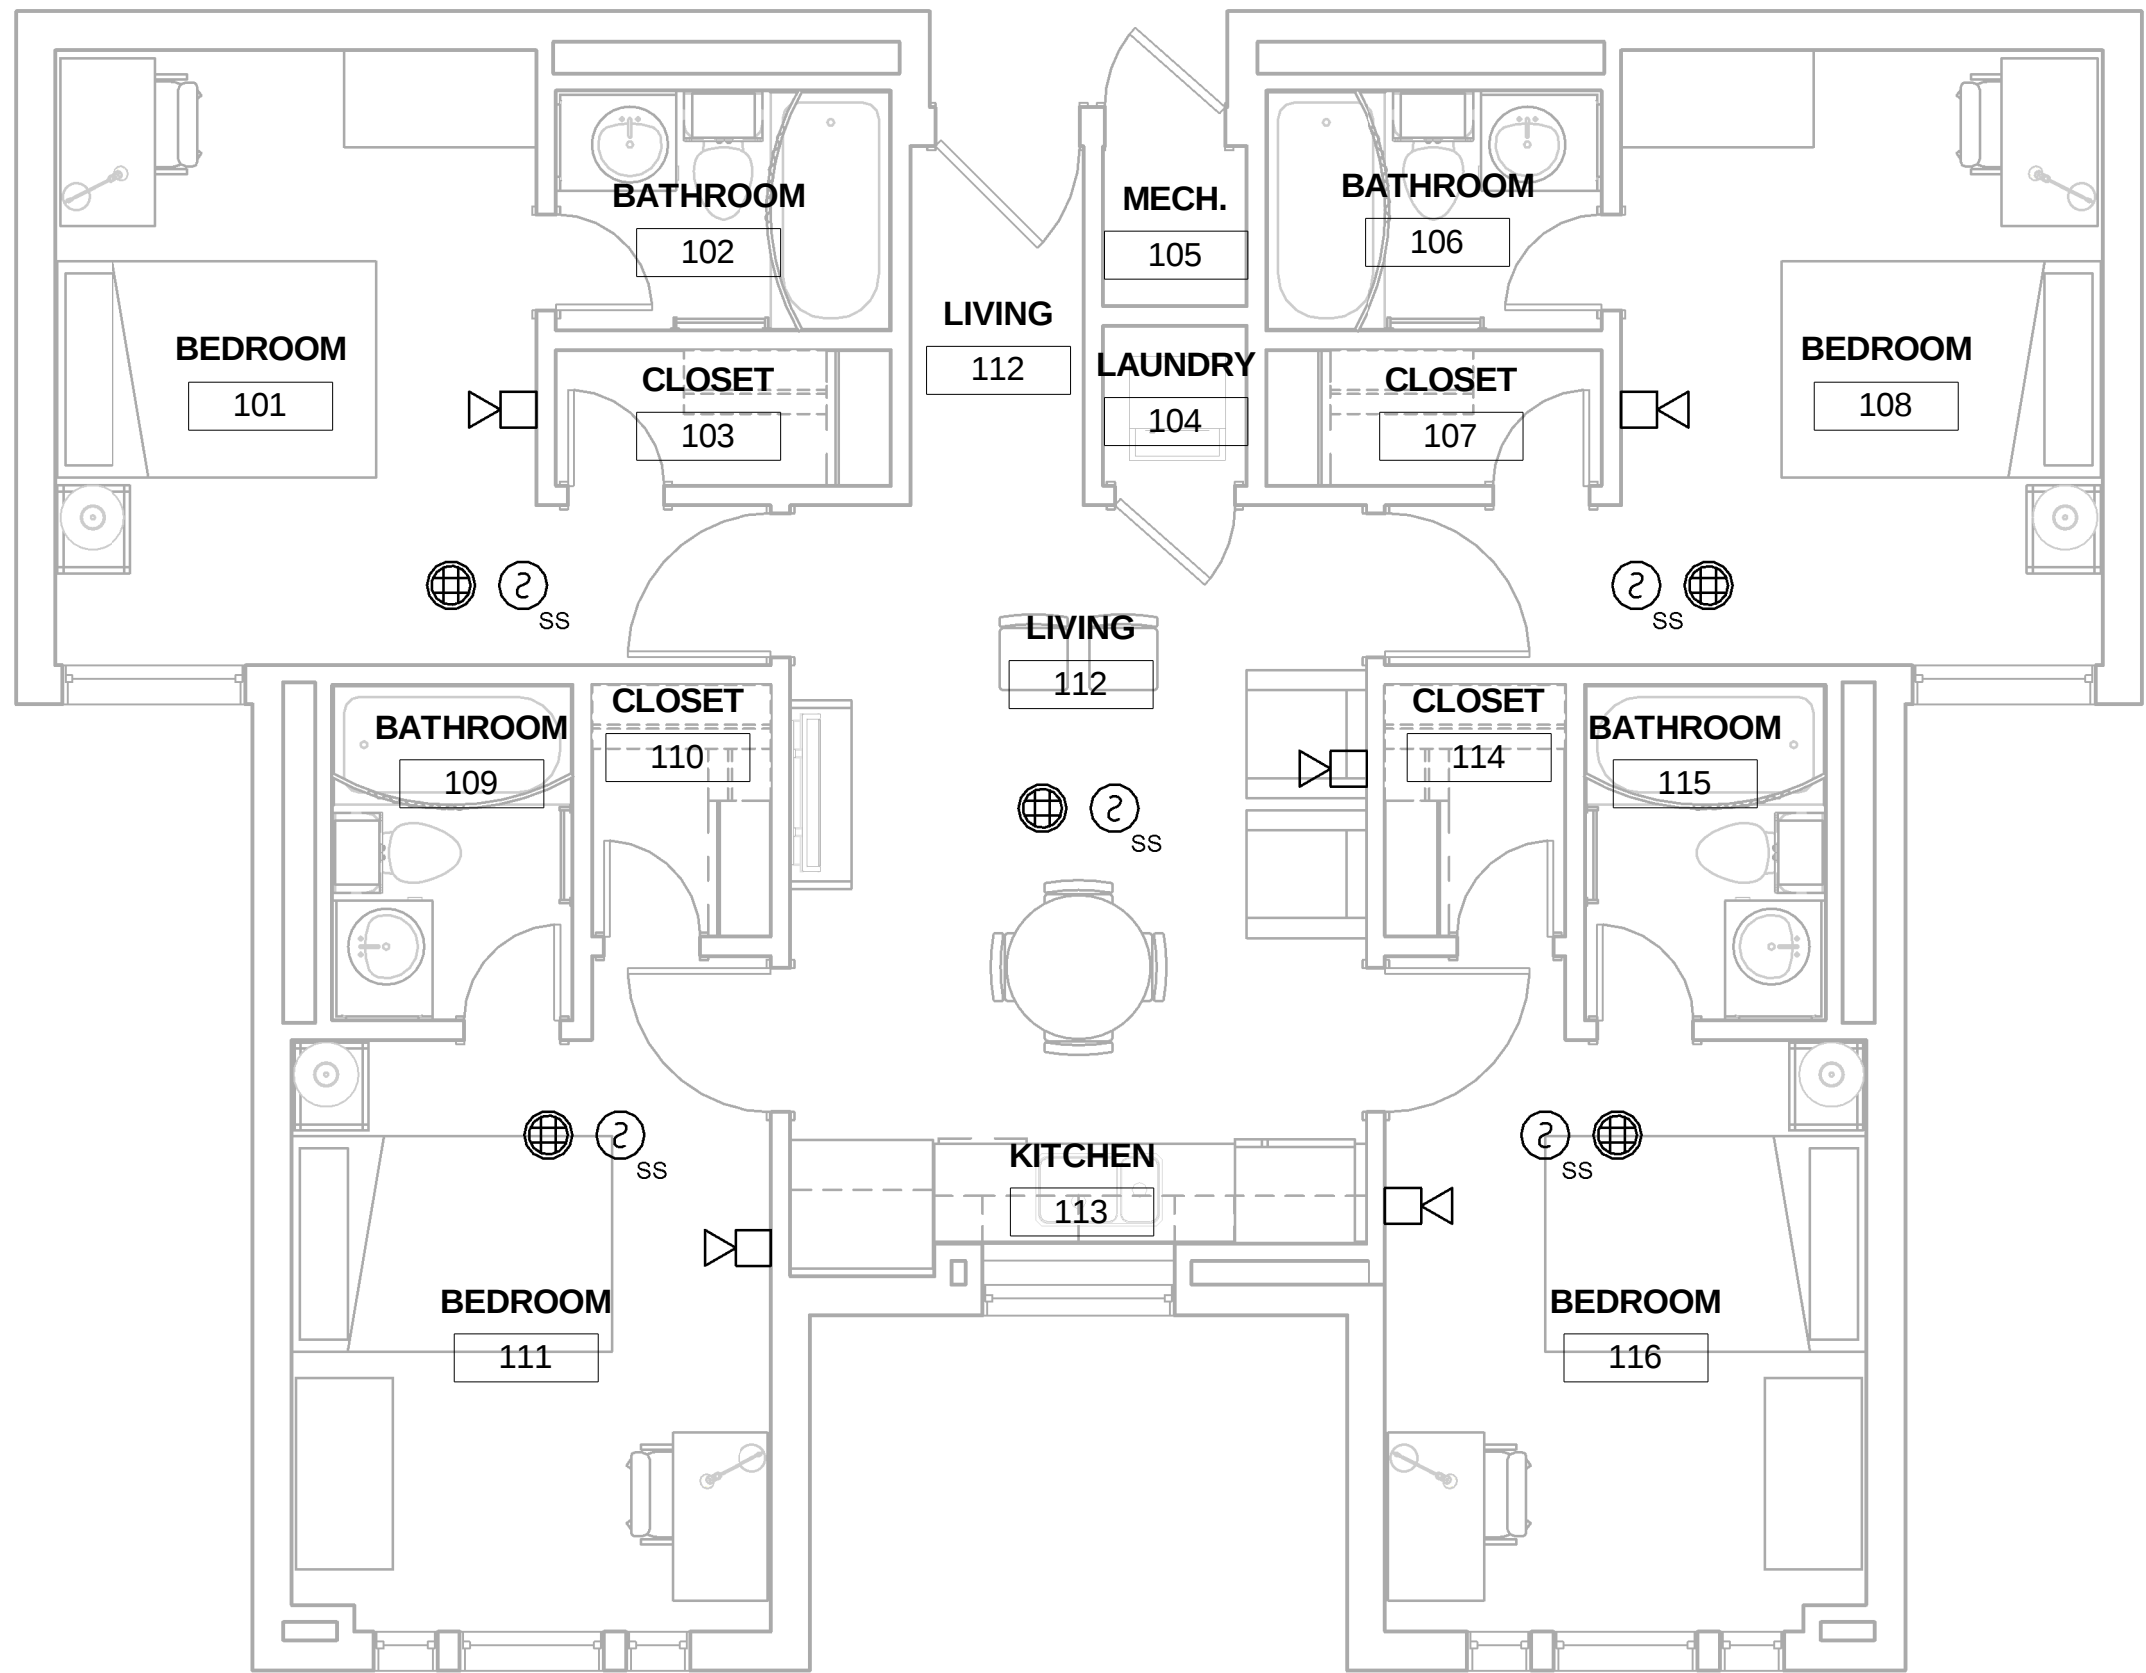

A1 PLAN A FIRE ALARM PLAN
1/4" = 1'-0"

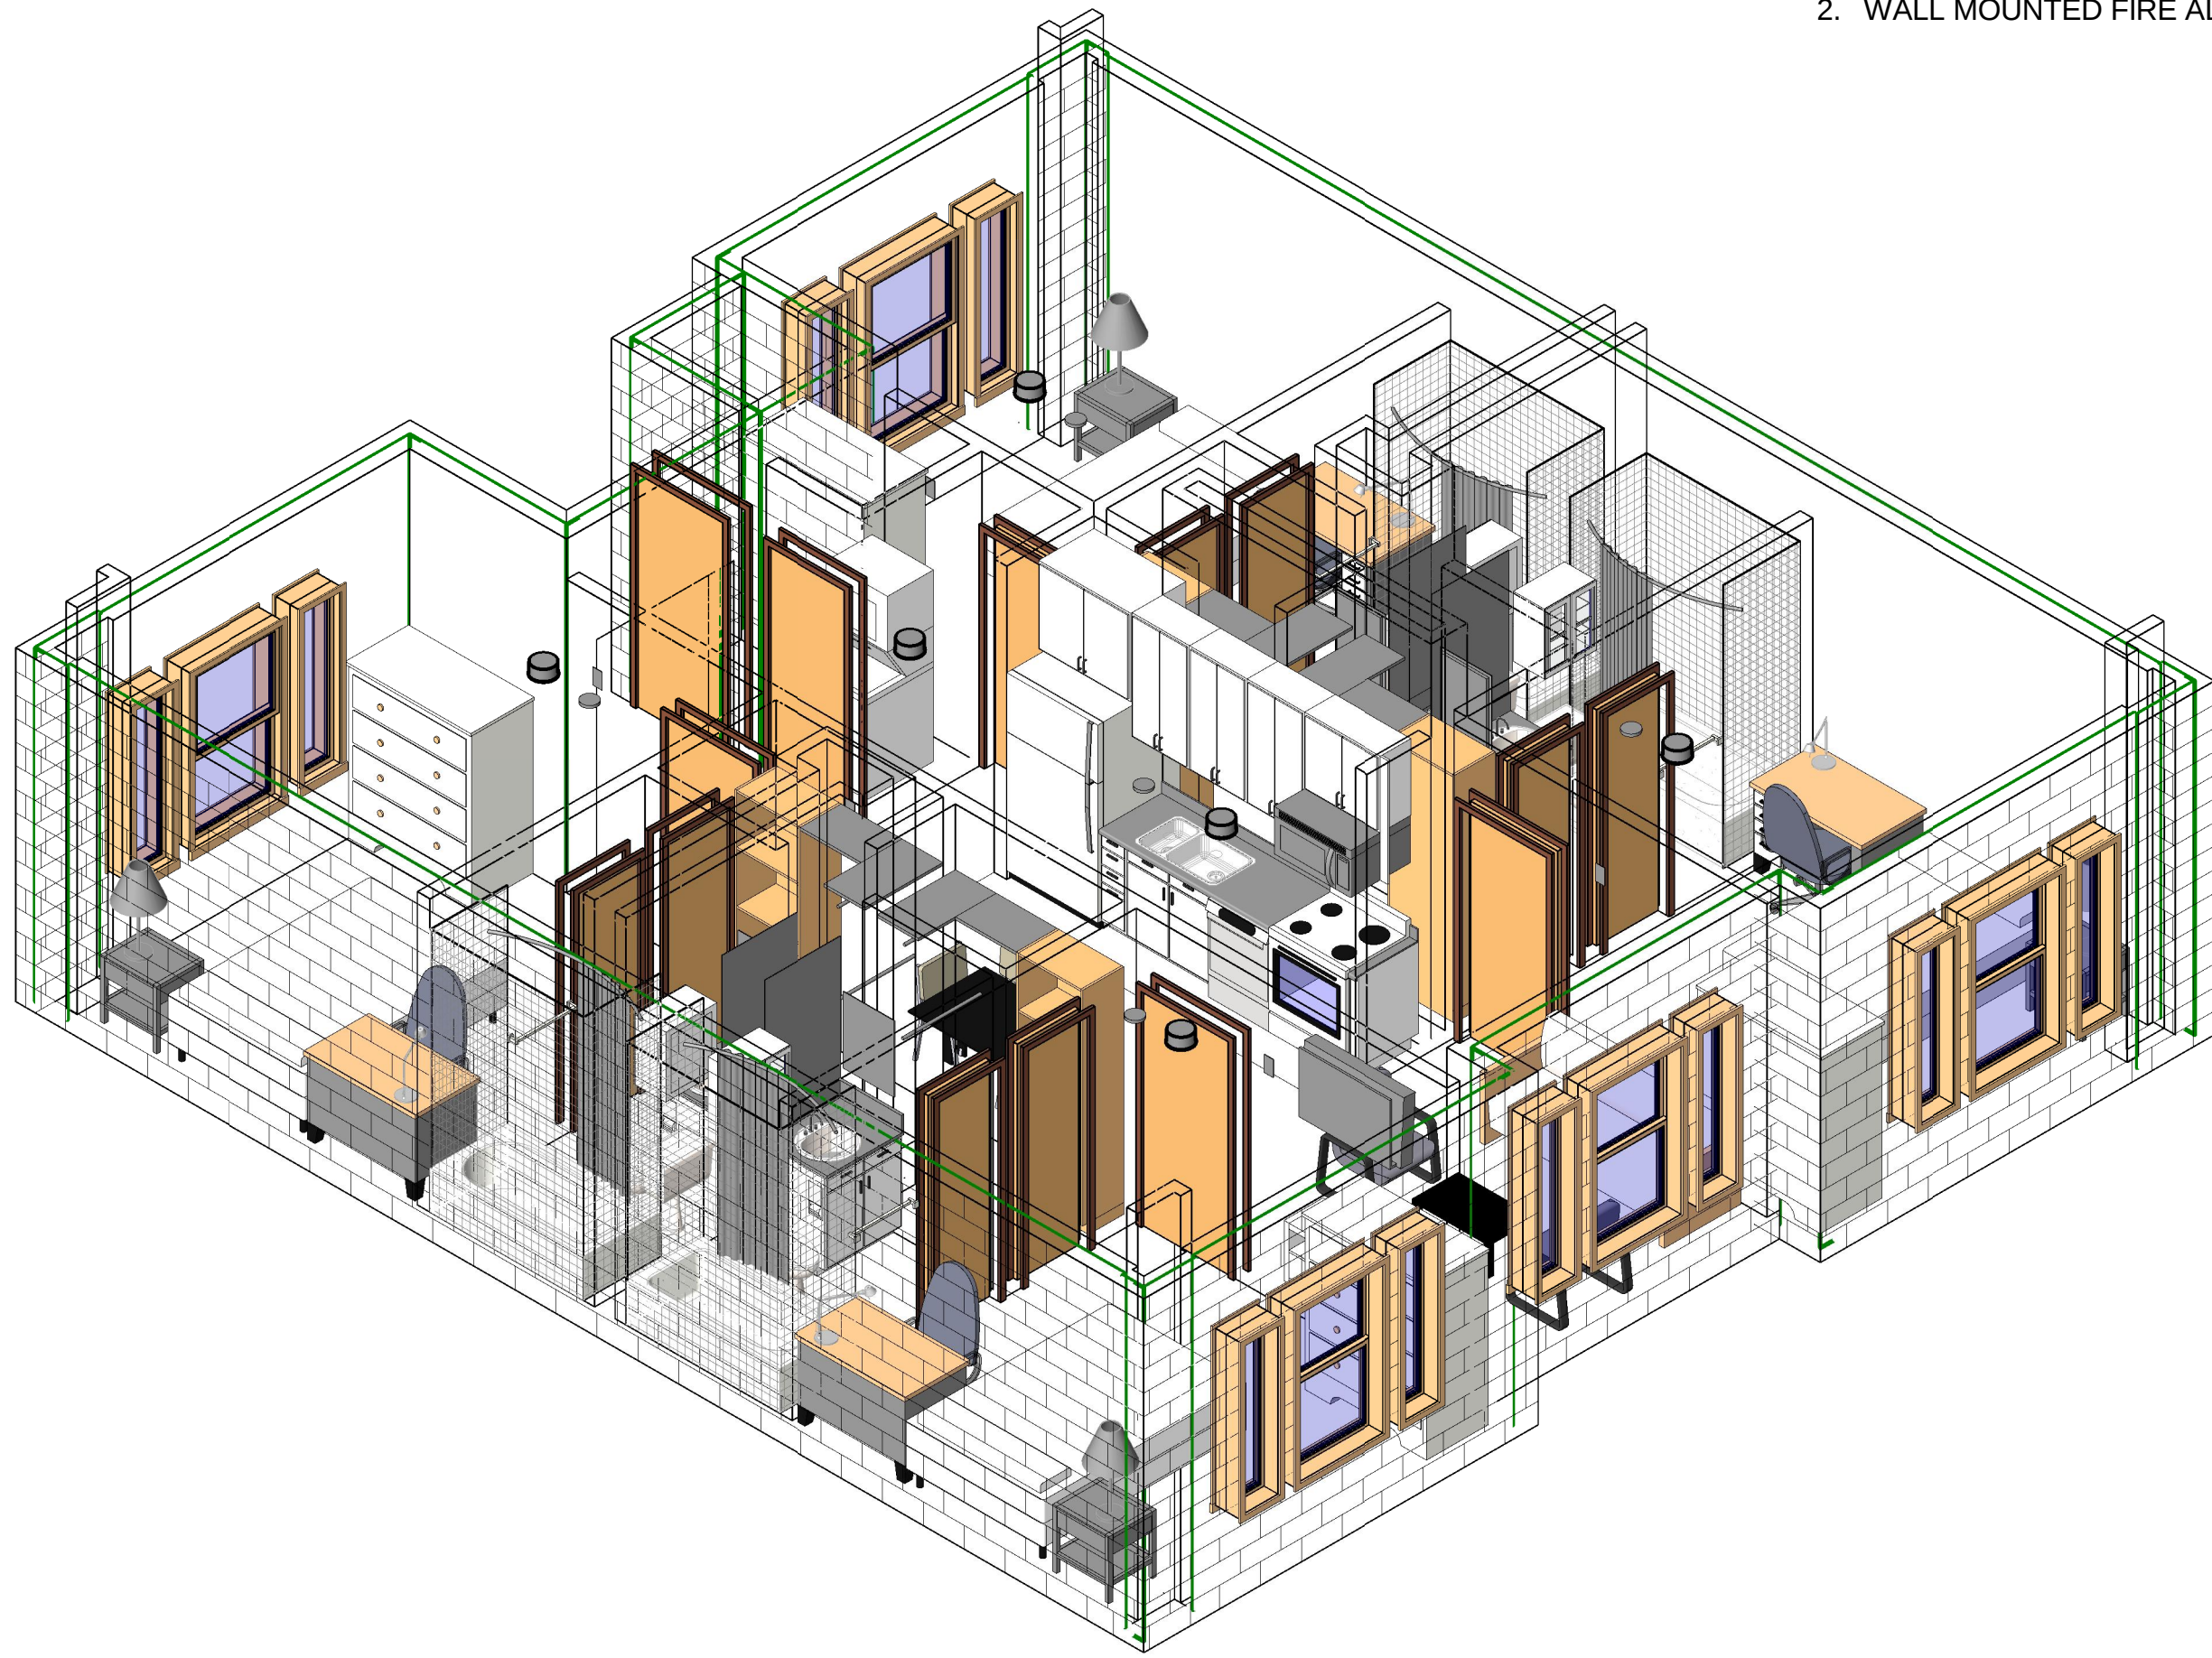

C3 PLAN B FIRE ALARM AXON

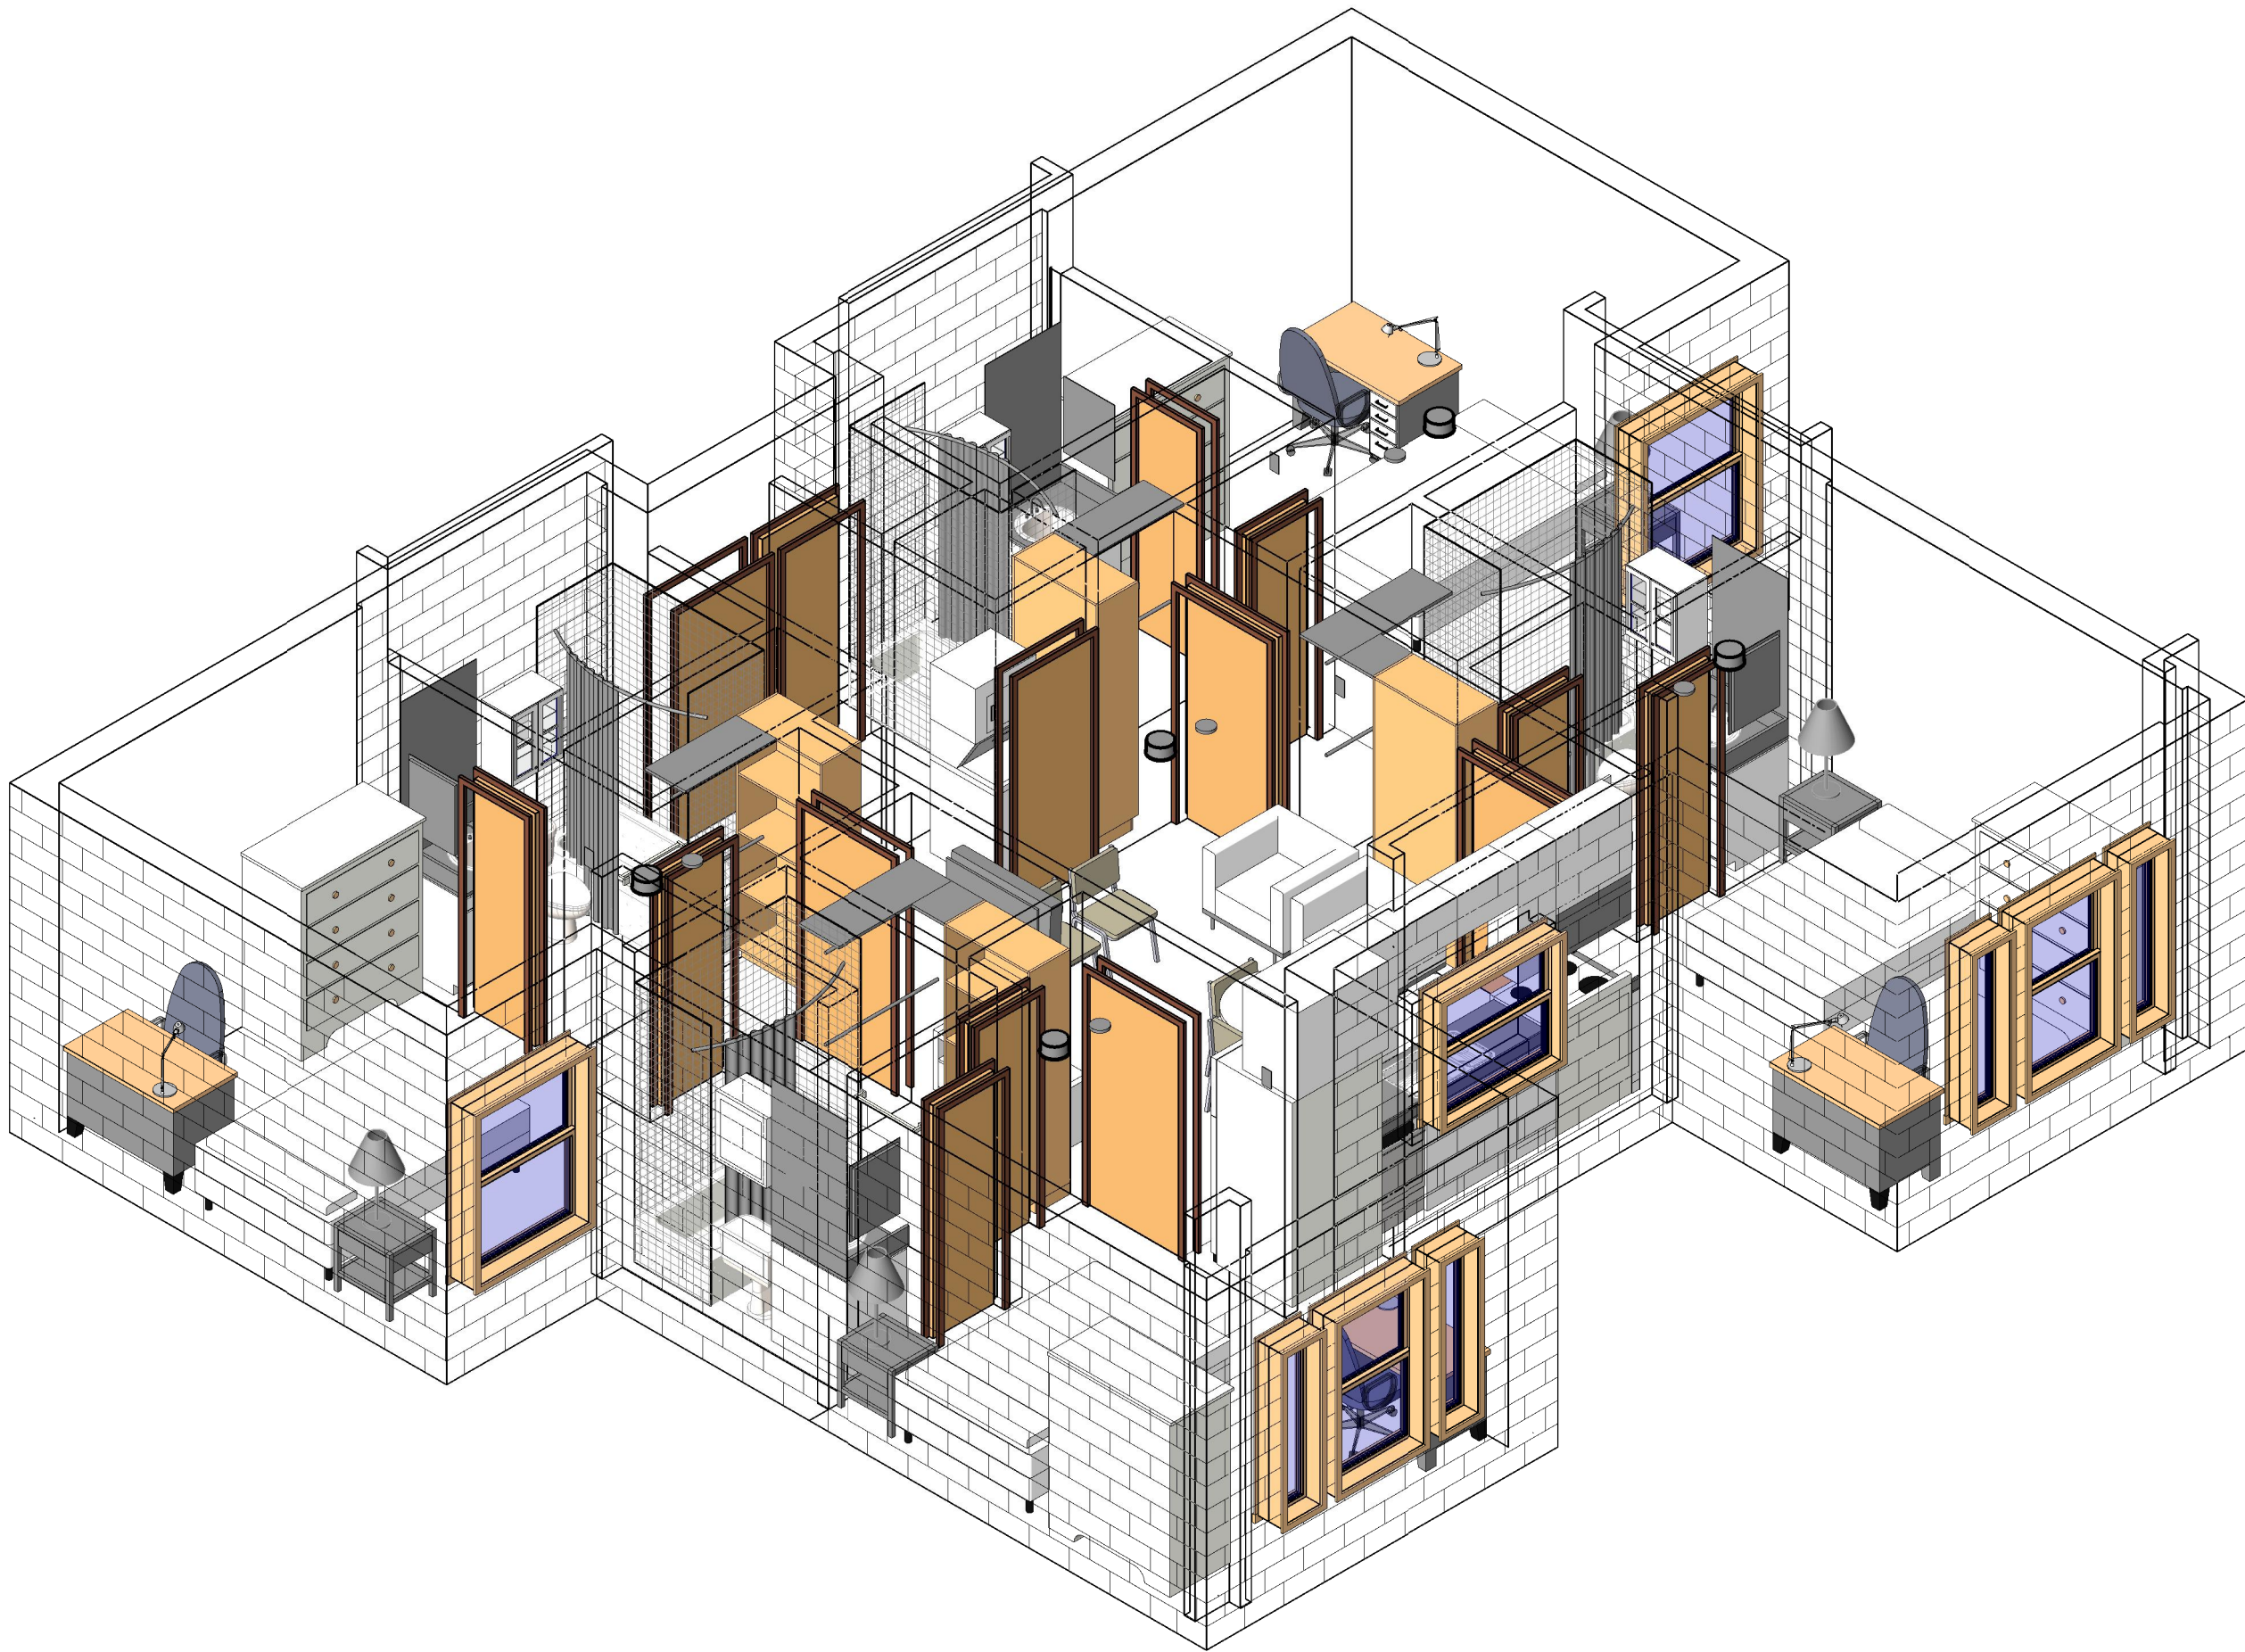

A3 PLAN A FIRE ALARM AXON

1

2

3

4

5

GENERAL NOTES

- 1. ALL SINGLE STATION SMOKE ALARMS WITHIN EACH DWELLING UNIT MUST BE INTERCONNECTED TO SOUND AT ONCE.
- 2. WALL MOUNTED FIRE ALARM SPEAKERS ARE MOUNTED AT 78" AFF.

JACOBS™

NOT FOR
CONSTRUCTION

911 Central Parkway N., Suite 425 San Antonio, TX 78323
501 North Broadway, St. Louis, Missouri 63102-2121

Revision:
Date: By: Description:

AIR FORCE CENTER FOR ENGINEERING AND THE
ENVIRONMENT (AFCEE)
FACILITIES DYNAMIC PROTOTYPES DESIGN FOR
DORMITORIES

Scales: 1/4" = 1'-0"

Jacobs Project No.: FDWD1301

Drawing Title:

FIRE ALARM
PLANS/AXON

Date: May 11, 2009


Designed By: Designer

Drawn By: SBW

Checked By: Checker

Drawing No.:

FA102

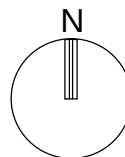


D

C

B


A

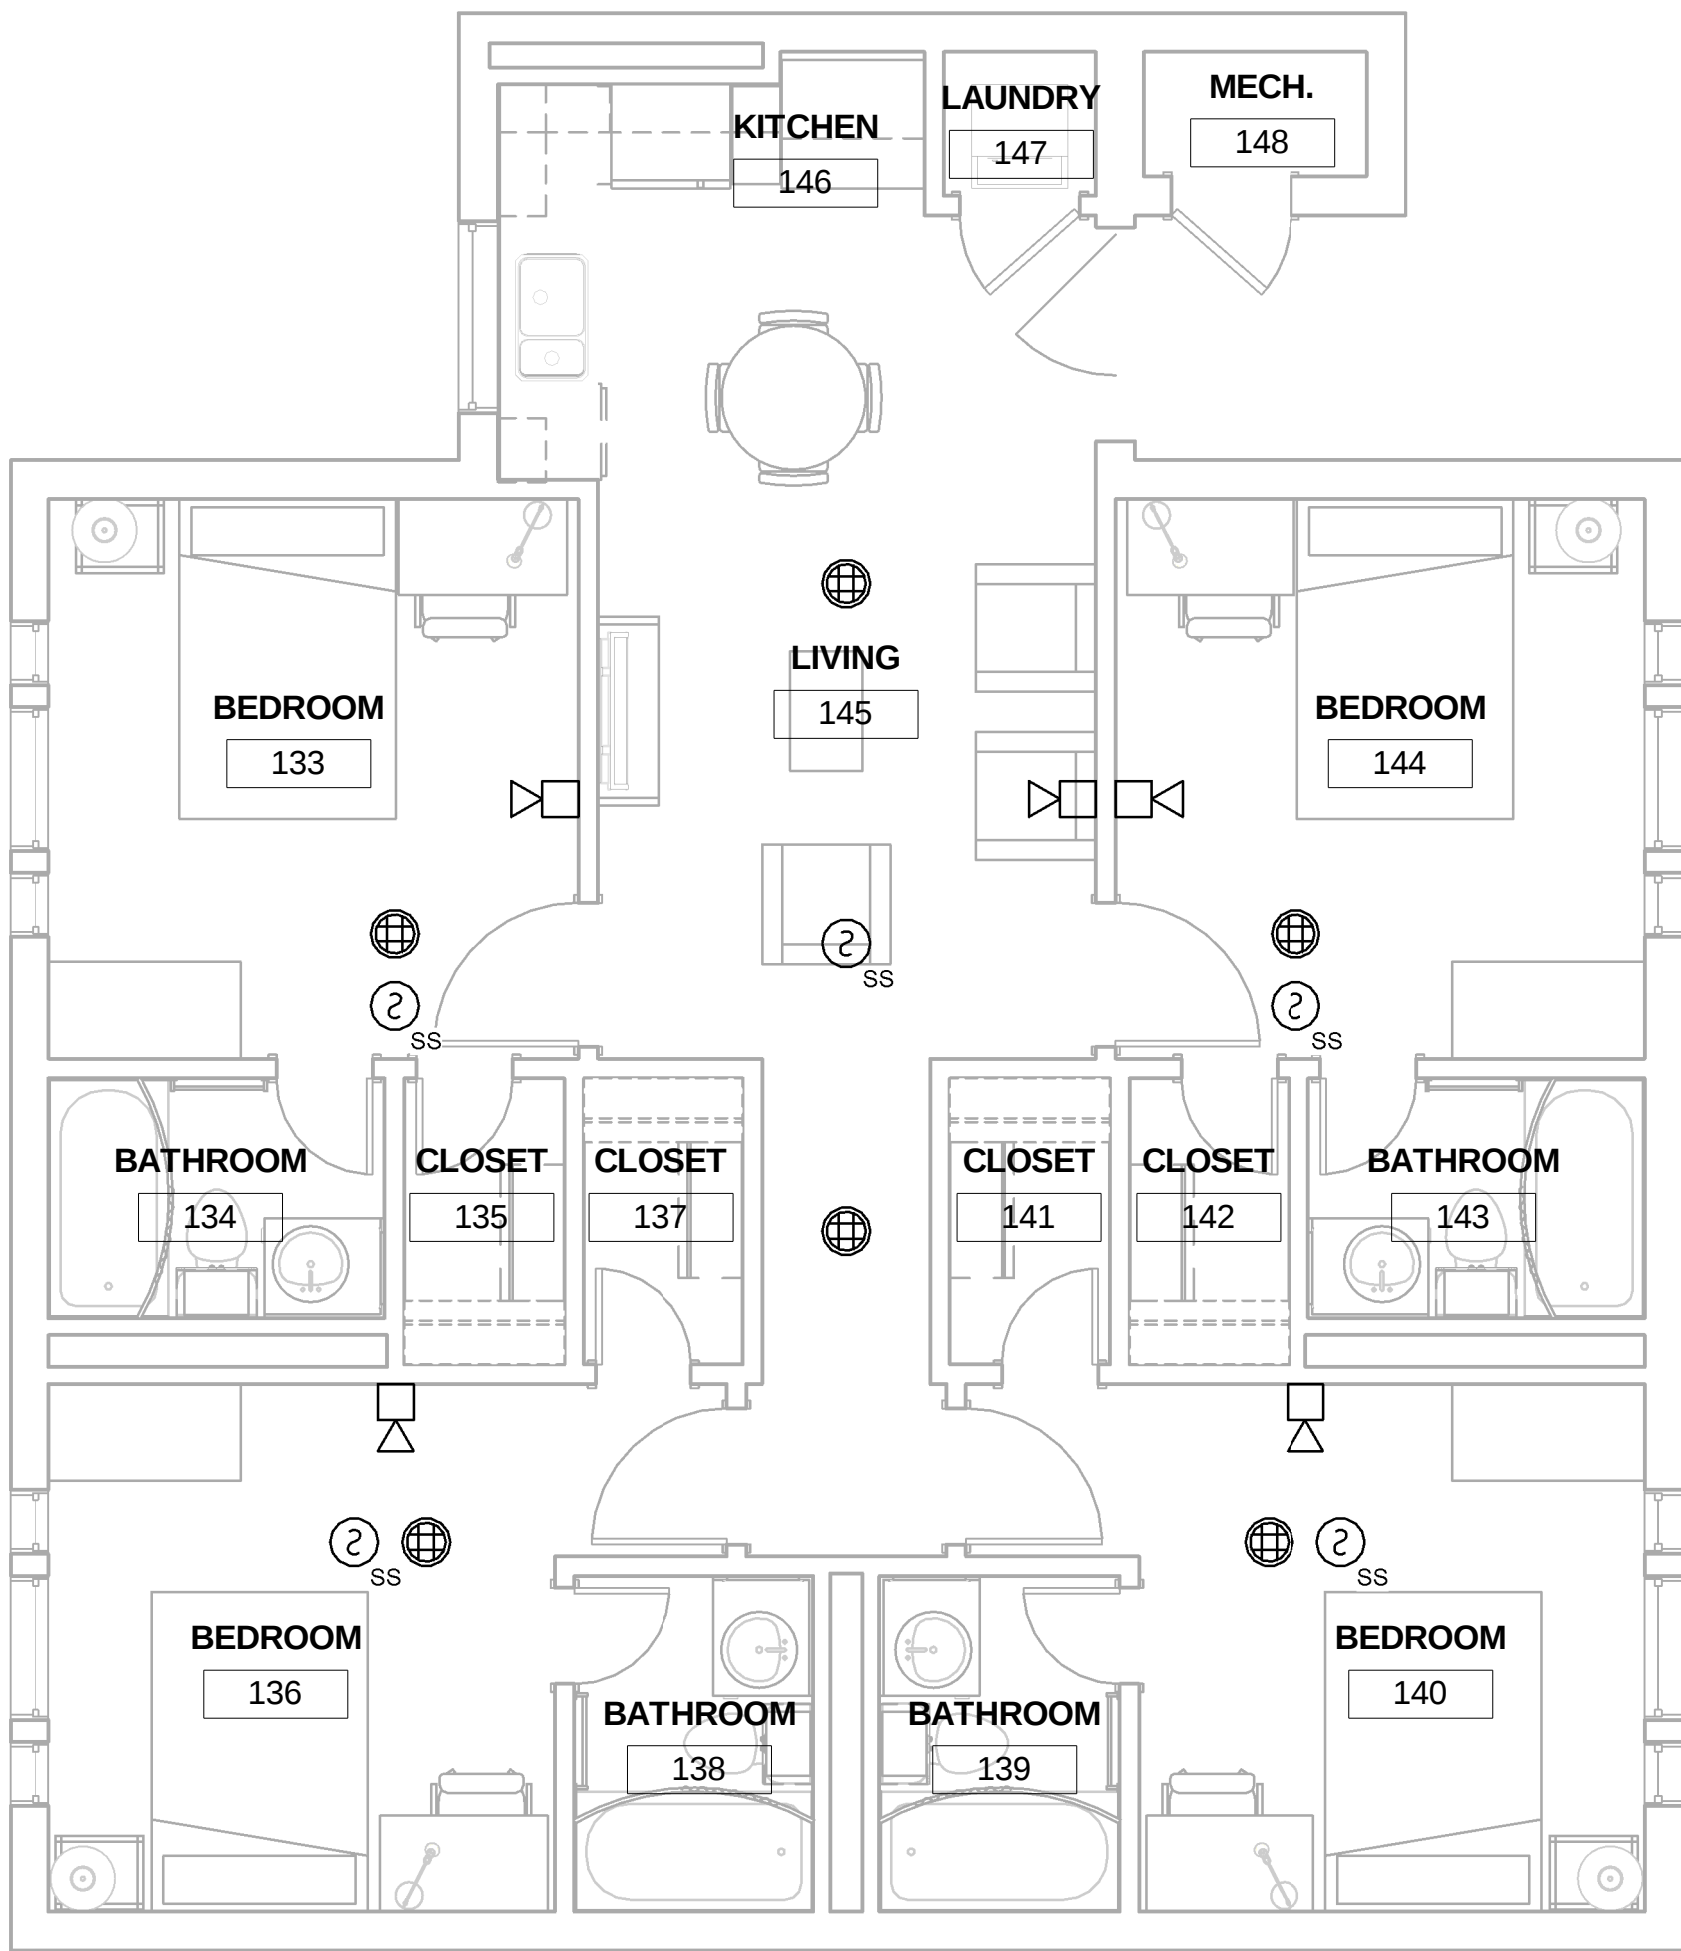

A1 PLAN C FIRE ALARM PLAN
1/4" = 1'-0"




1 PLAN C FIRE ALARM AXON

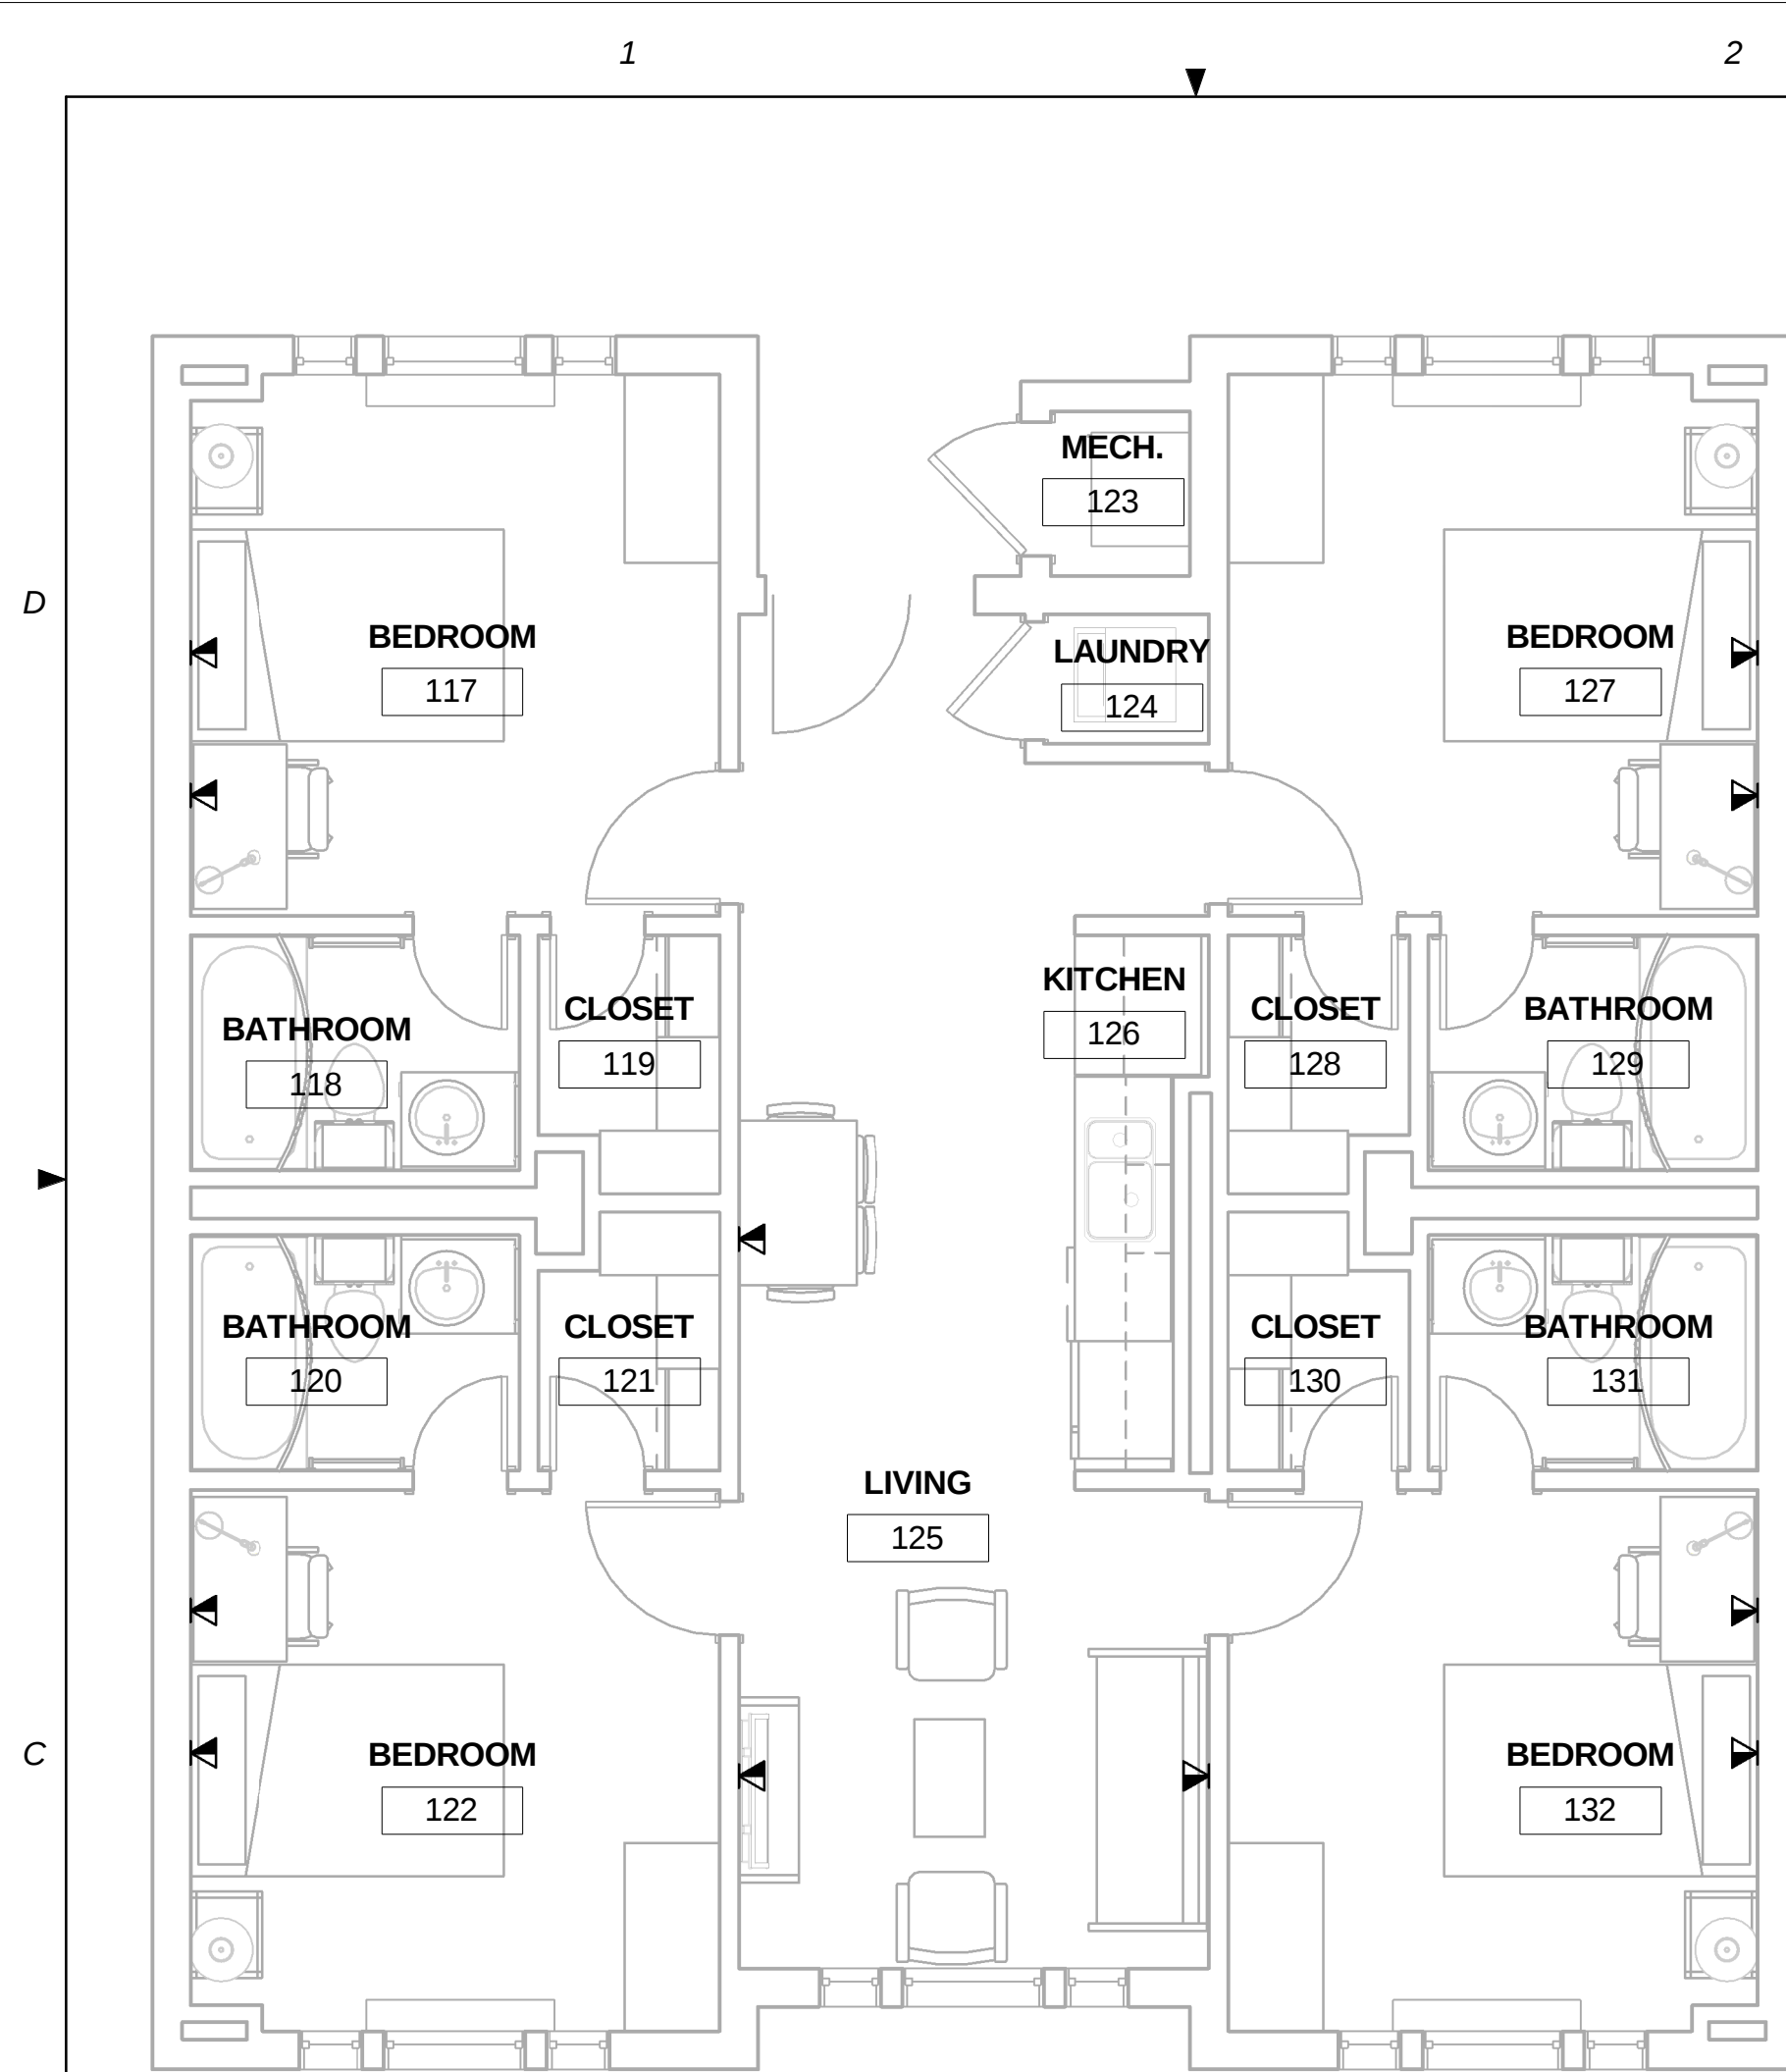

C1 PLAN B TELECOM PLAN
1/4" = 1'-0"



A1 PLAN A TELECOM PLAN
1/4" = 1'-0"

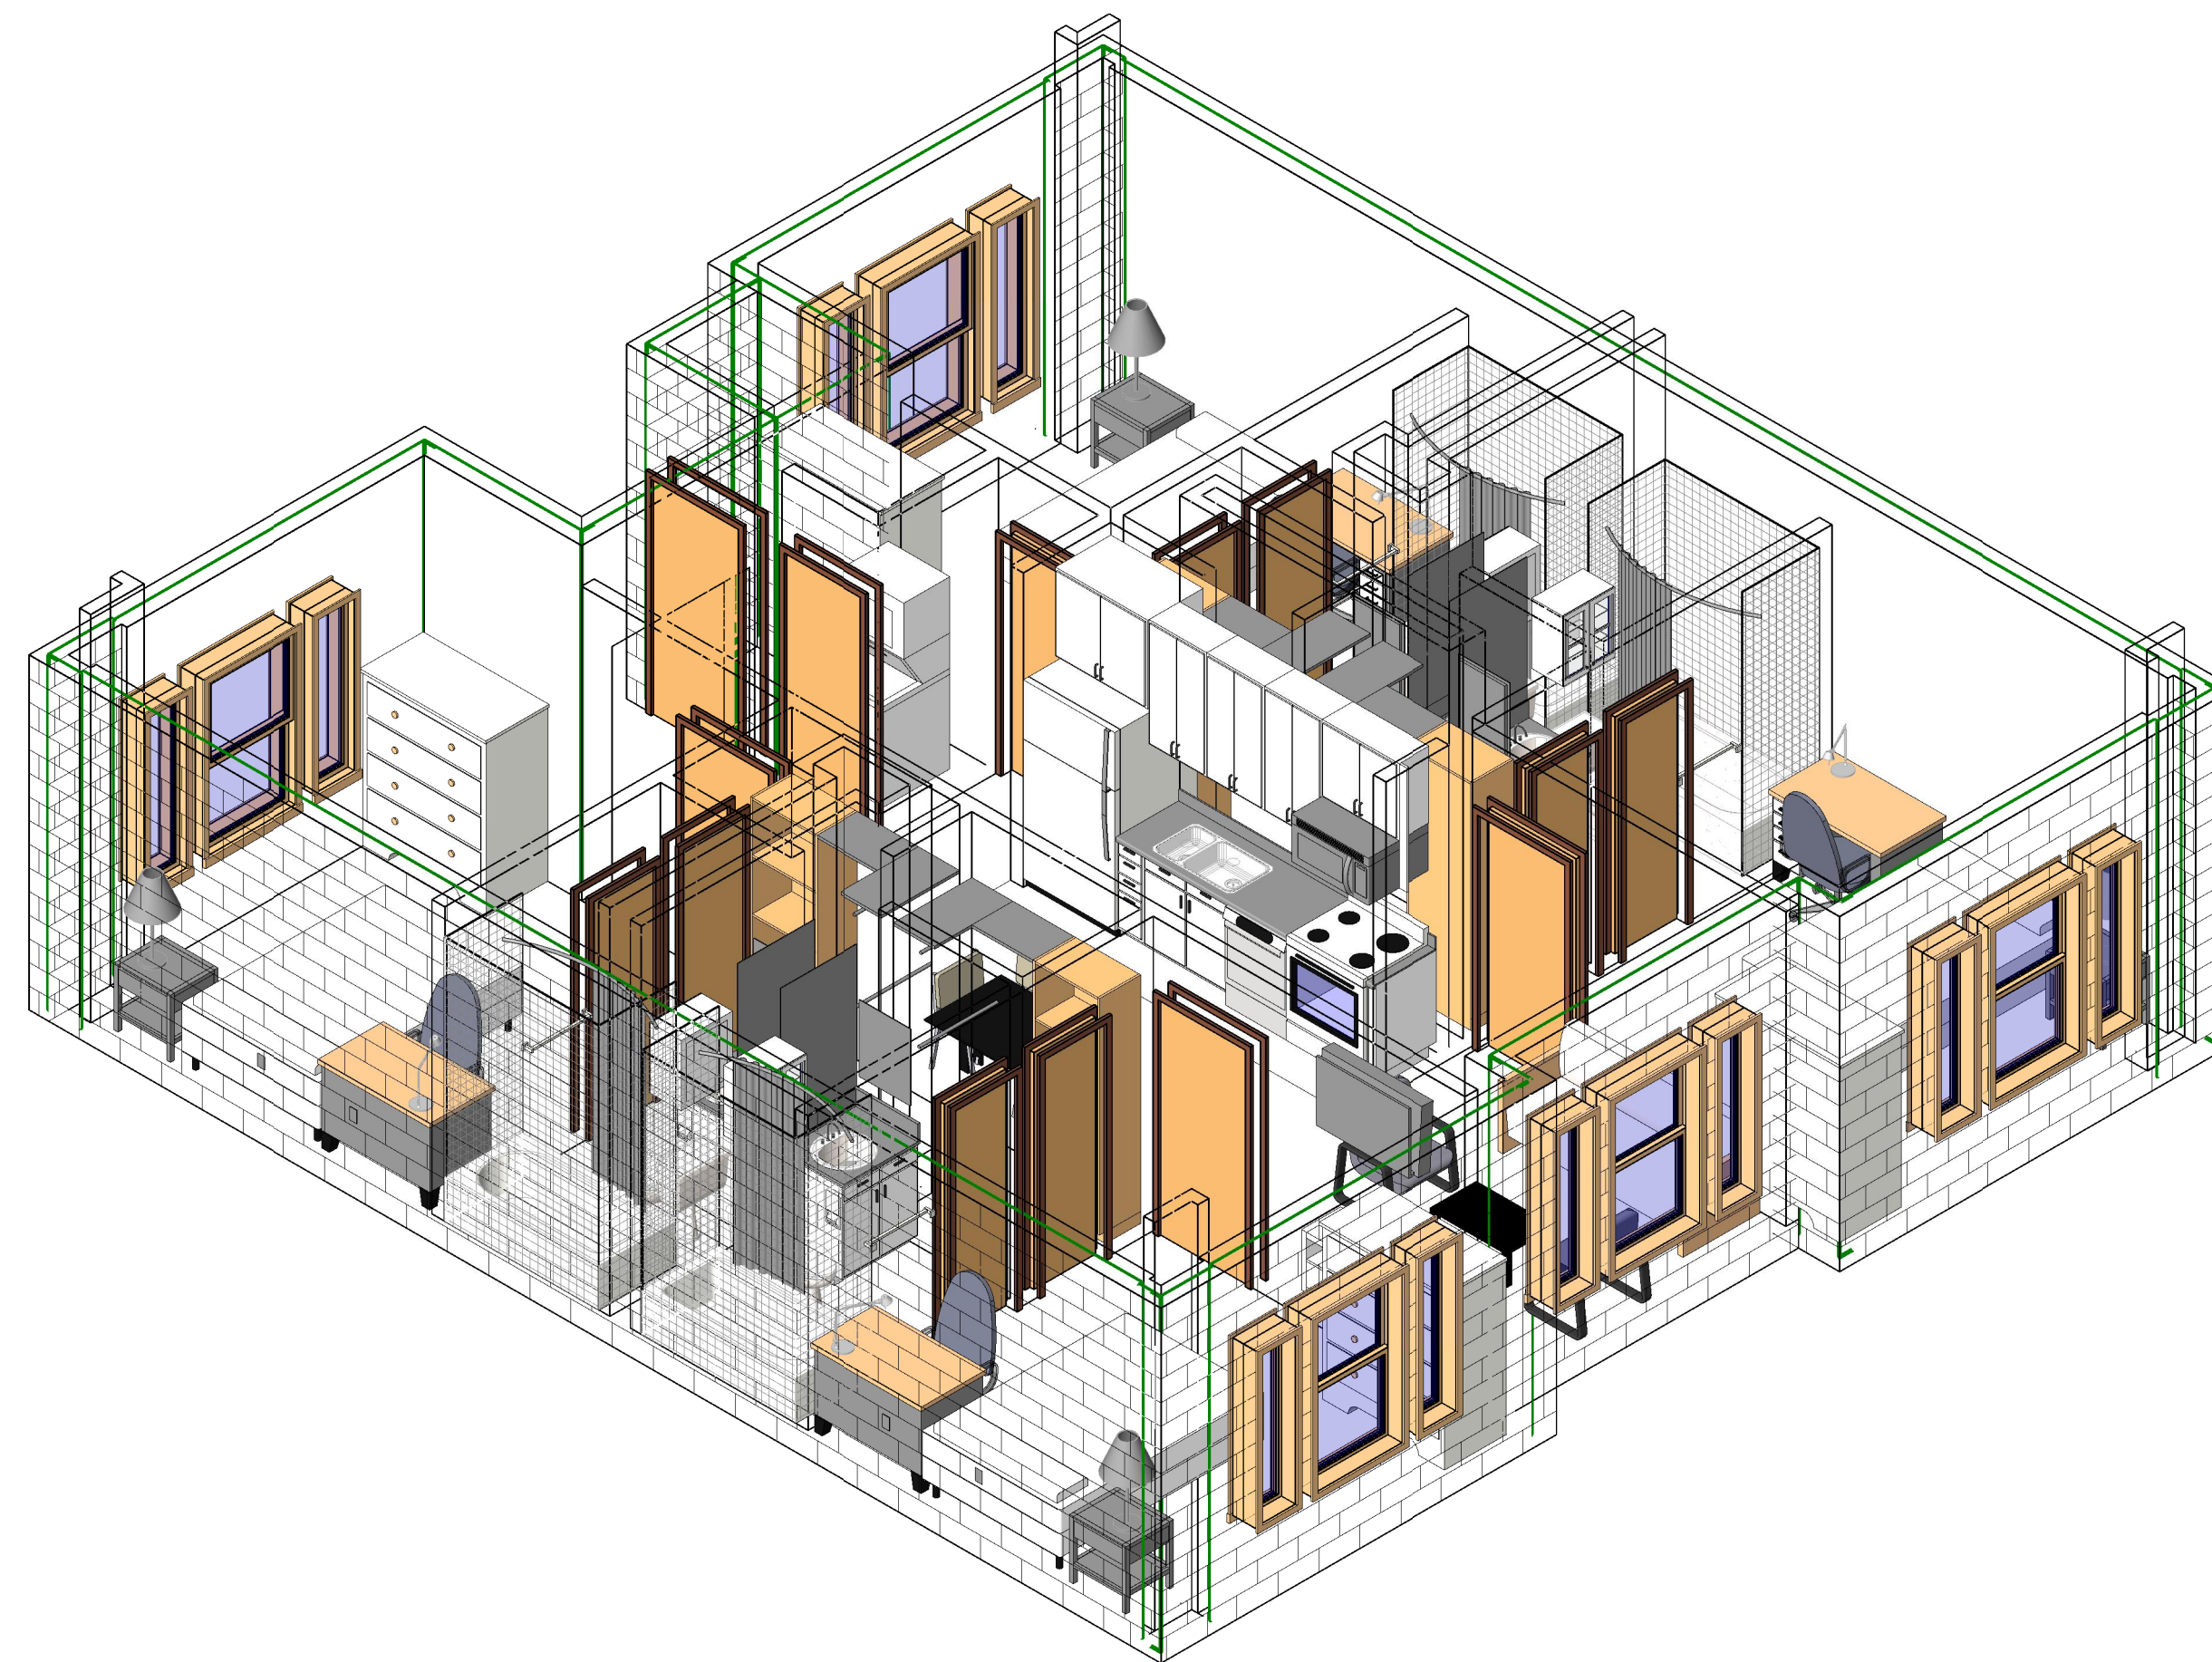

C3 PLAN B TELECOM AXON



A3 PLAN A TELECOM AXON

GENERAL NOTES

1. DATA OUTLETS ARE MOUNTED AT 18" AFF UNLESS OTHERWISE NOTED.

JACOBS

NOT FOR
CONSTRUCTION

911 Central Parkway N., Suite 425 San Antonio, TX 78323
501 North Broadway, St. Louis, Missouri 63102-2121

Revision:
Date: By: Description:

AIR FORCE CENTER FOR ENGINEERING AND THE
ENVIRONMENT (AFCEE)
FACILITIES DYNAMIC PROTOTYPES DESIGN FOR
DORMITORIES

Scales: 1/4" = 1'-0"

Jacobs Project No.: FDWD1301

Drawing Title:

TELECOM
PLANS/AXON

Date: May 11, 2009


Designed By: Designer

Drawn By: SBW

Checked By: Checker

Drawing No.:

T-101

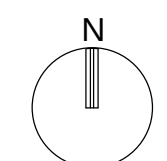

1

2

3

4

5

GENERAL NOTES

1. DATA OUTLETS ARE MOUNTED AT 18" AFF UNLESS OTHERWISE NOTED.

JACOBS™

NOT FOR
CONSTRUCTION

911 Central Parkway N., Suite 425 San Antonio, TX 78323
501 North Broadway, St. Louis, Missouri 63102-2121

Revision:
Date: By: Description:

AIR FORCE CENTER FOR ENGINEERING AND THE
ENVIRONMENT (AFCEE)
FACILITIES DYNAMIC PROTOTYPES DESIGN FOR
DORMITORIES

Scales: 1/4" = 1'-0"

Jacobs Project No.: FDWD1301

Drawing Title:

TELECOM
PLANS/AXON

Date: May 11, 2009


Designed By: Designer

Drawn By: SBW

Checked By: Checker

Drawing No.:

T-102

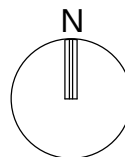


D

C

B

A

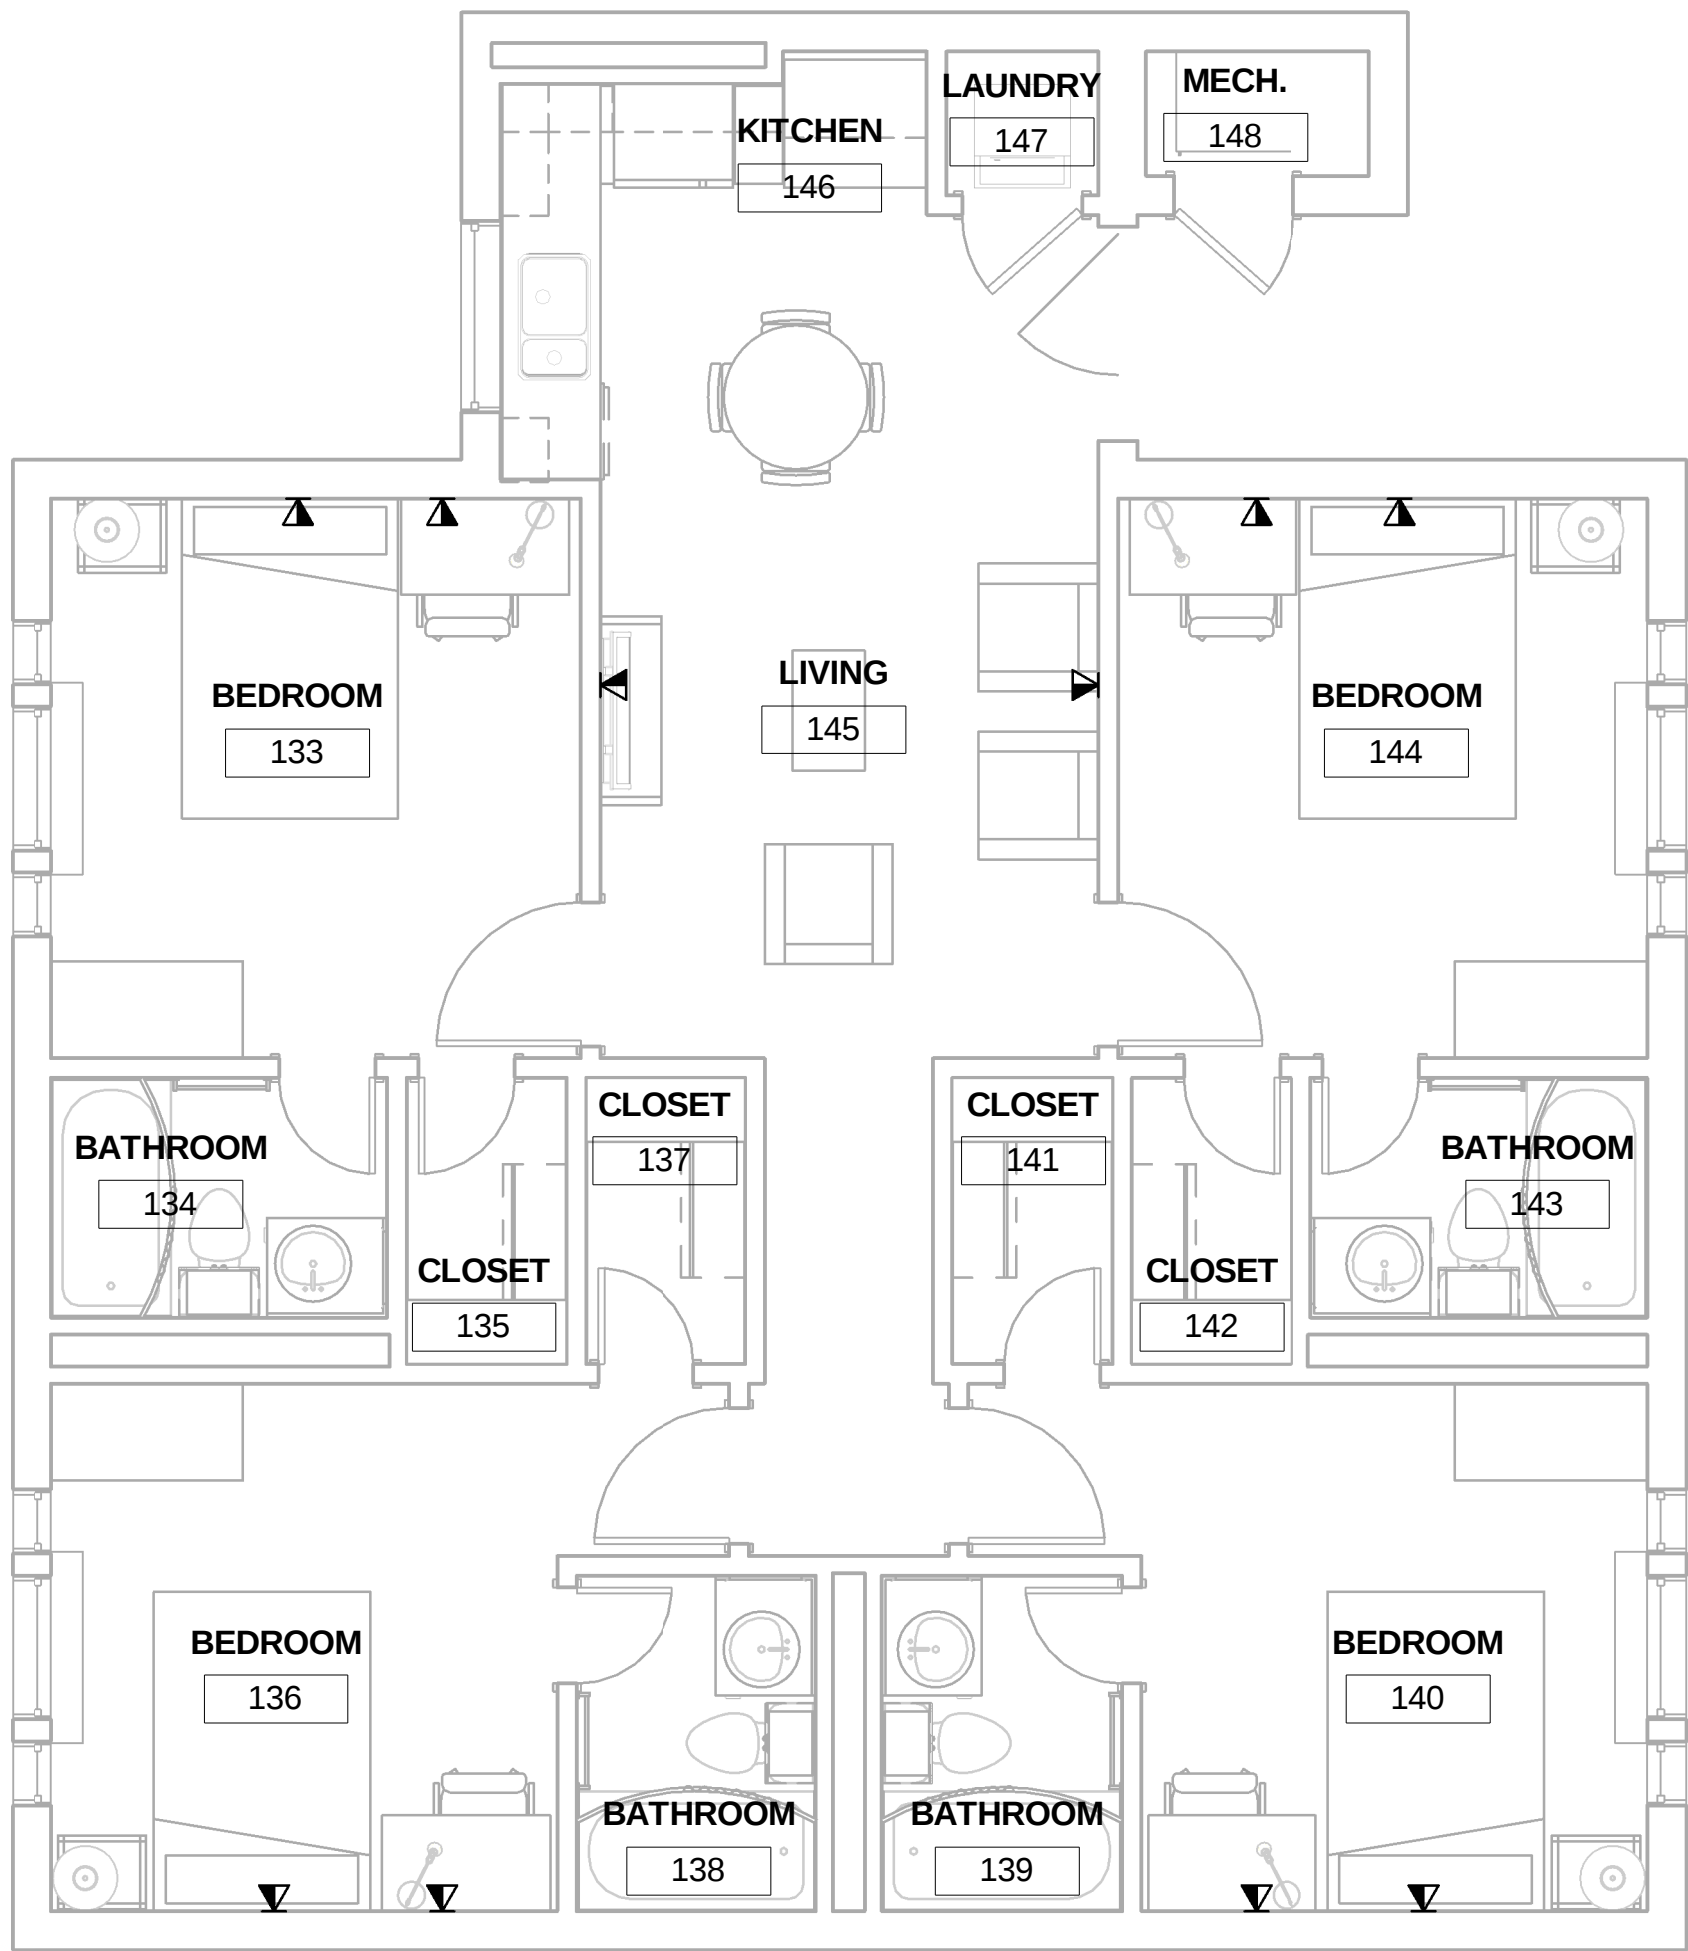

A1 PLAN C TELECOM PLAN
1/4" = 1'-0"



A3 PLAN C TELECOM AXON

AIR FORCE CENTER FOR ENGINEERING AND THE
ENVIRONMENT (AFCEE)
FACILITIES DYNAMIC PROTOTYPES DESIGN FOR
DORMITORIES

Scales: 1/4" = 1'-0"

Jacobs Project No.: FDWD1301

Drawing Title:

FIRE PROTECTION
PLANS

Date: 11 MAY 2009


Designed By: Designer

Drawn By: Author


Checked By: Checker

Drawing No.:


FP01

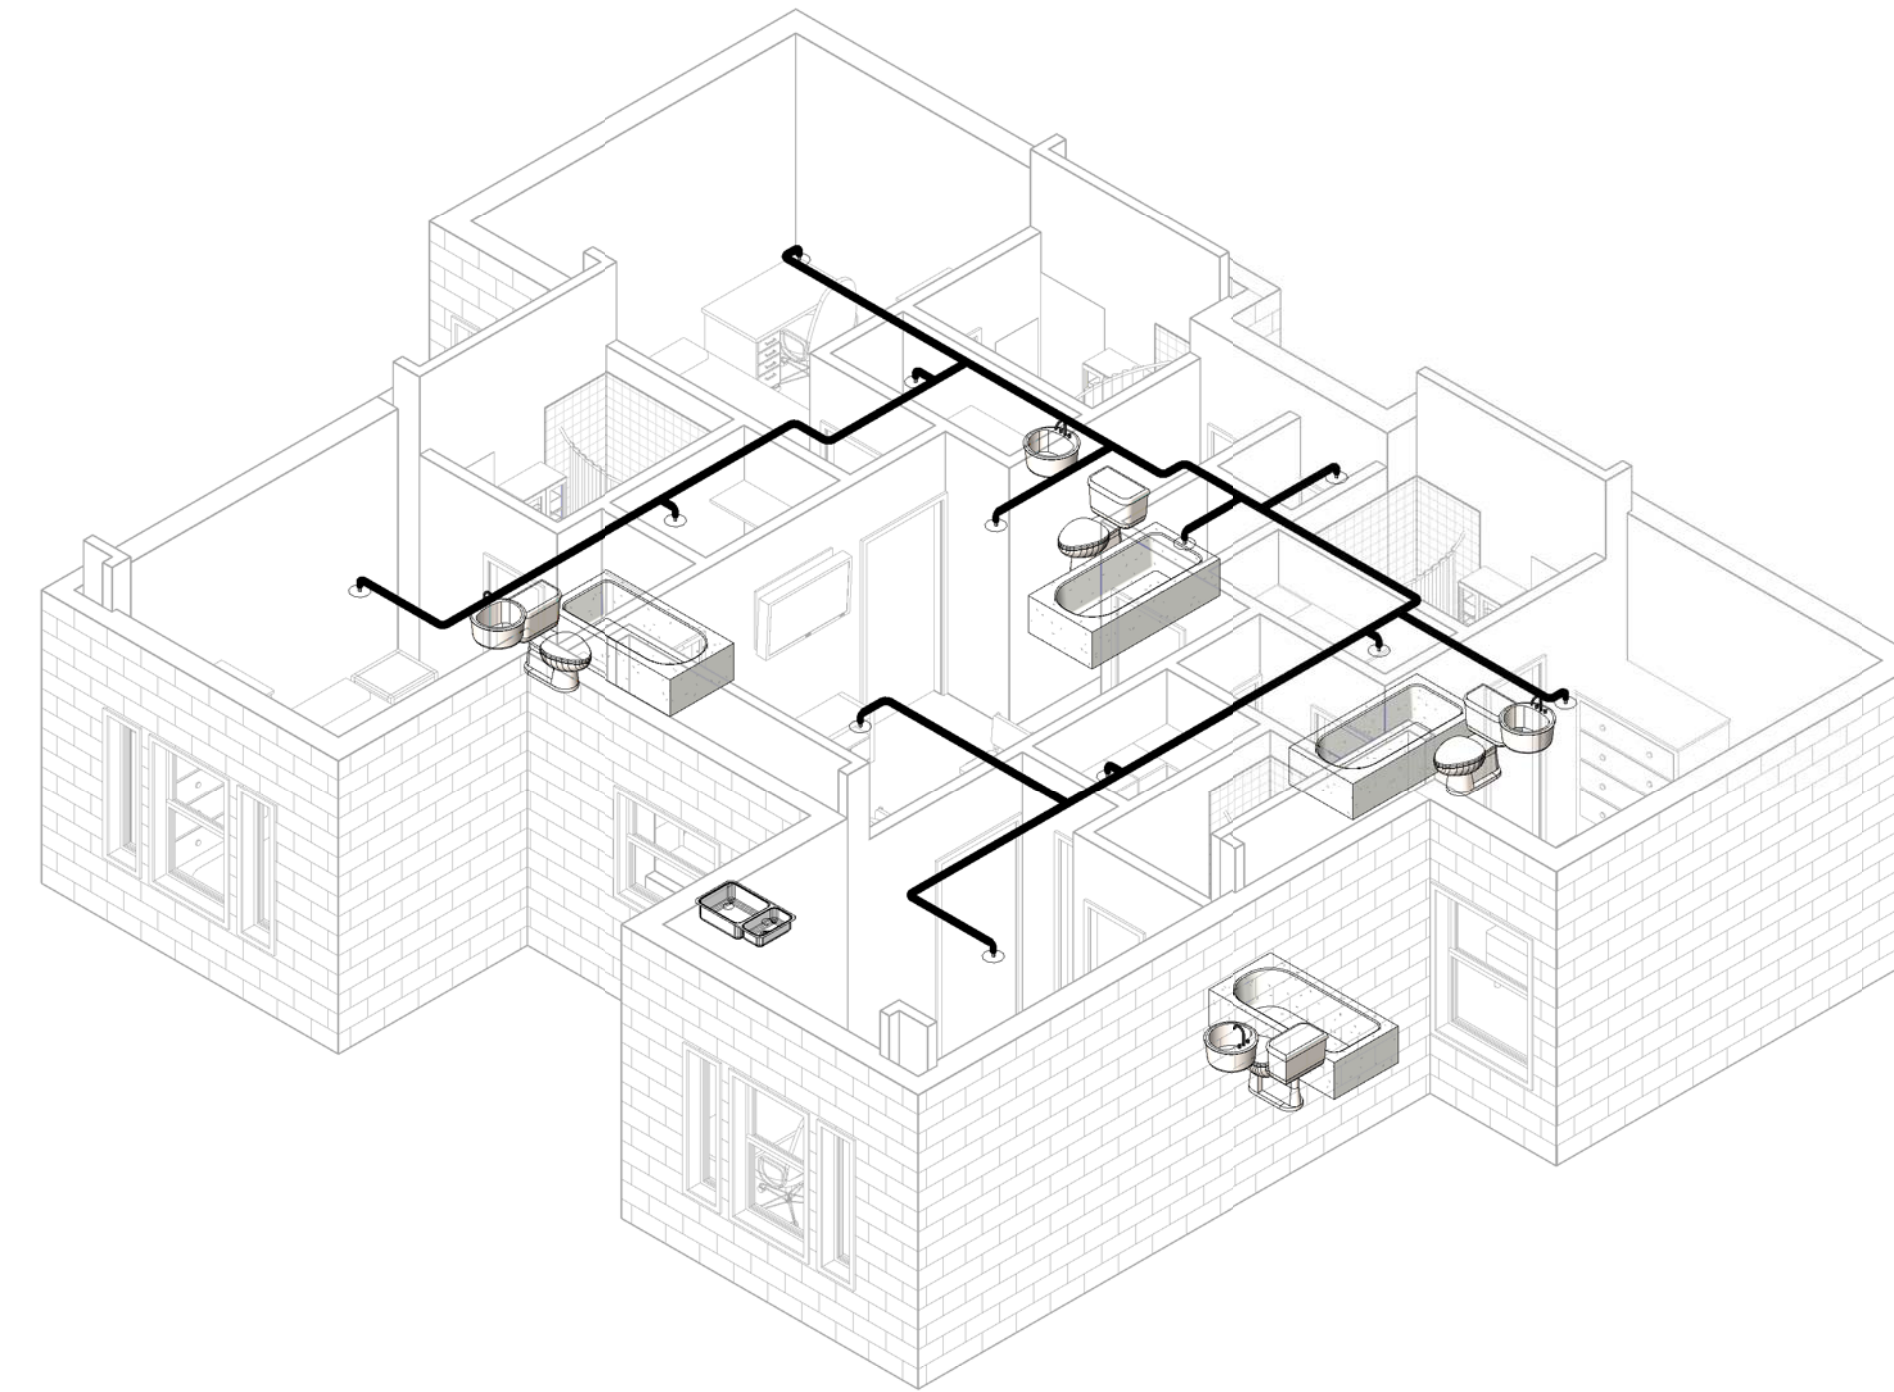


③ 3D FIRE PROTECTION A

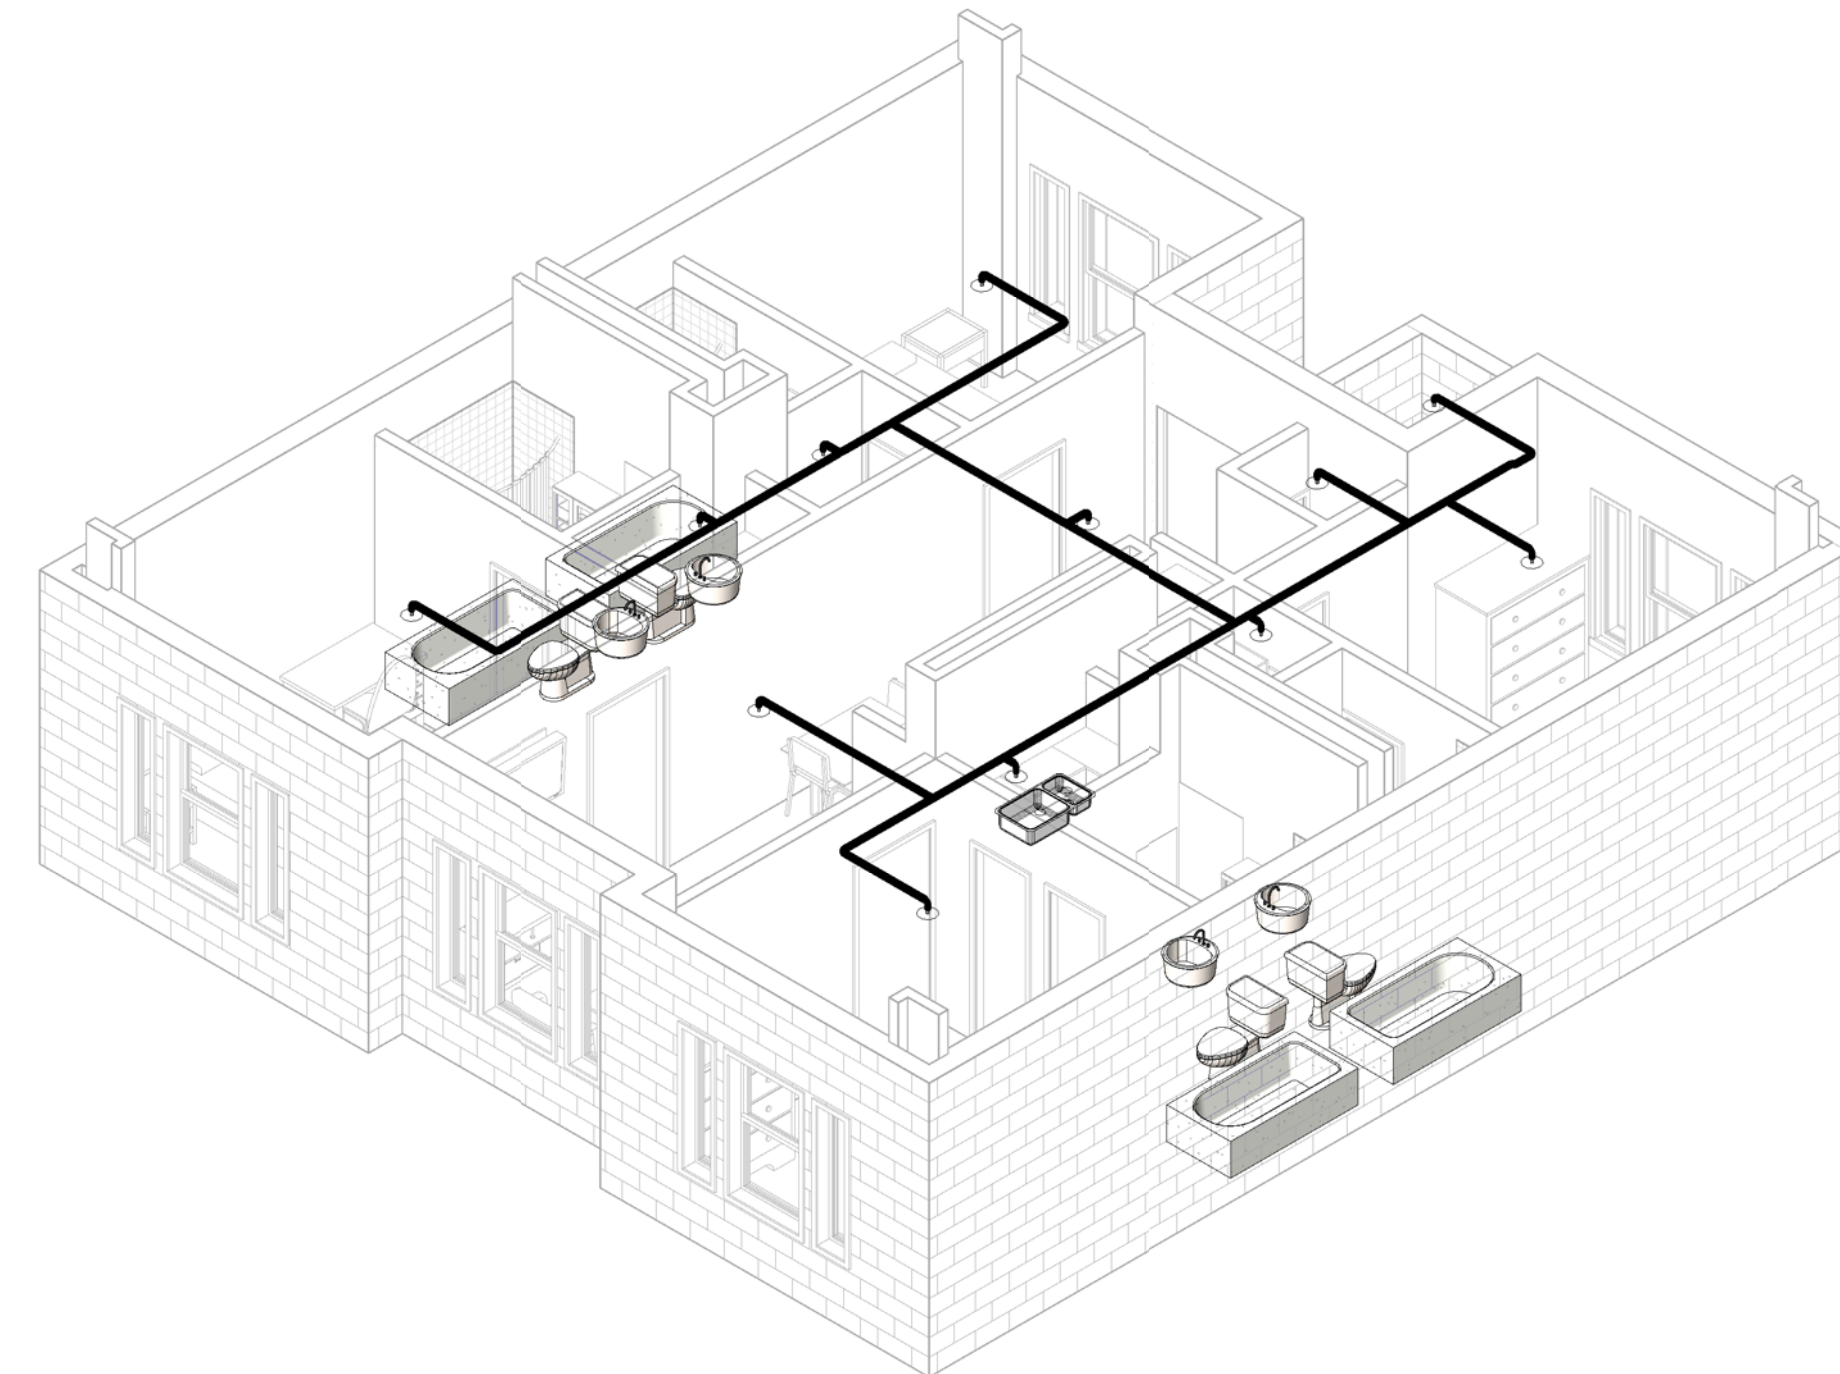

④ 3D FIRE PROTECTION B

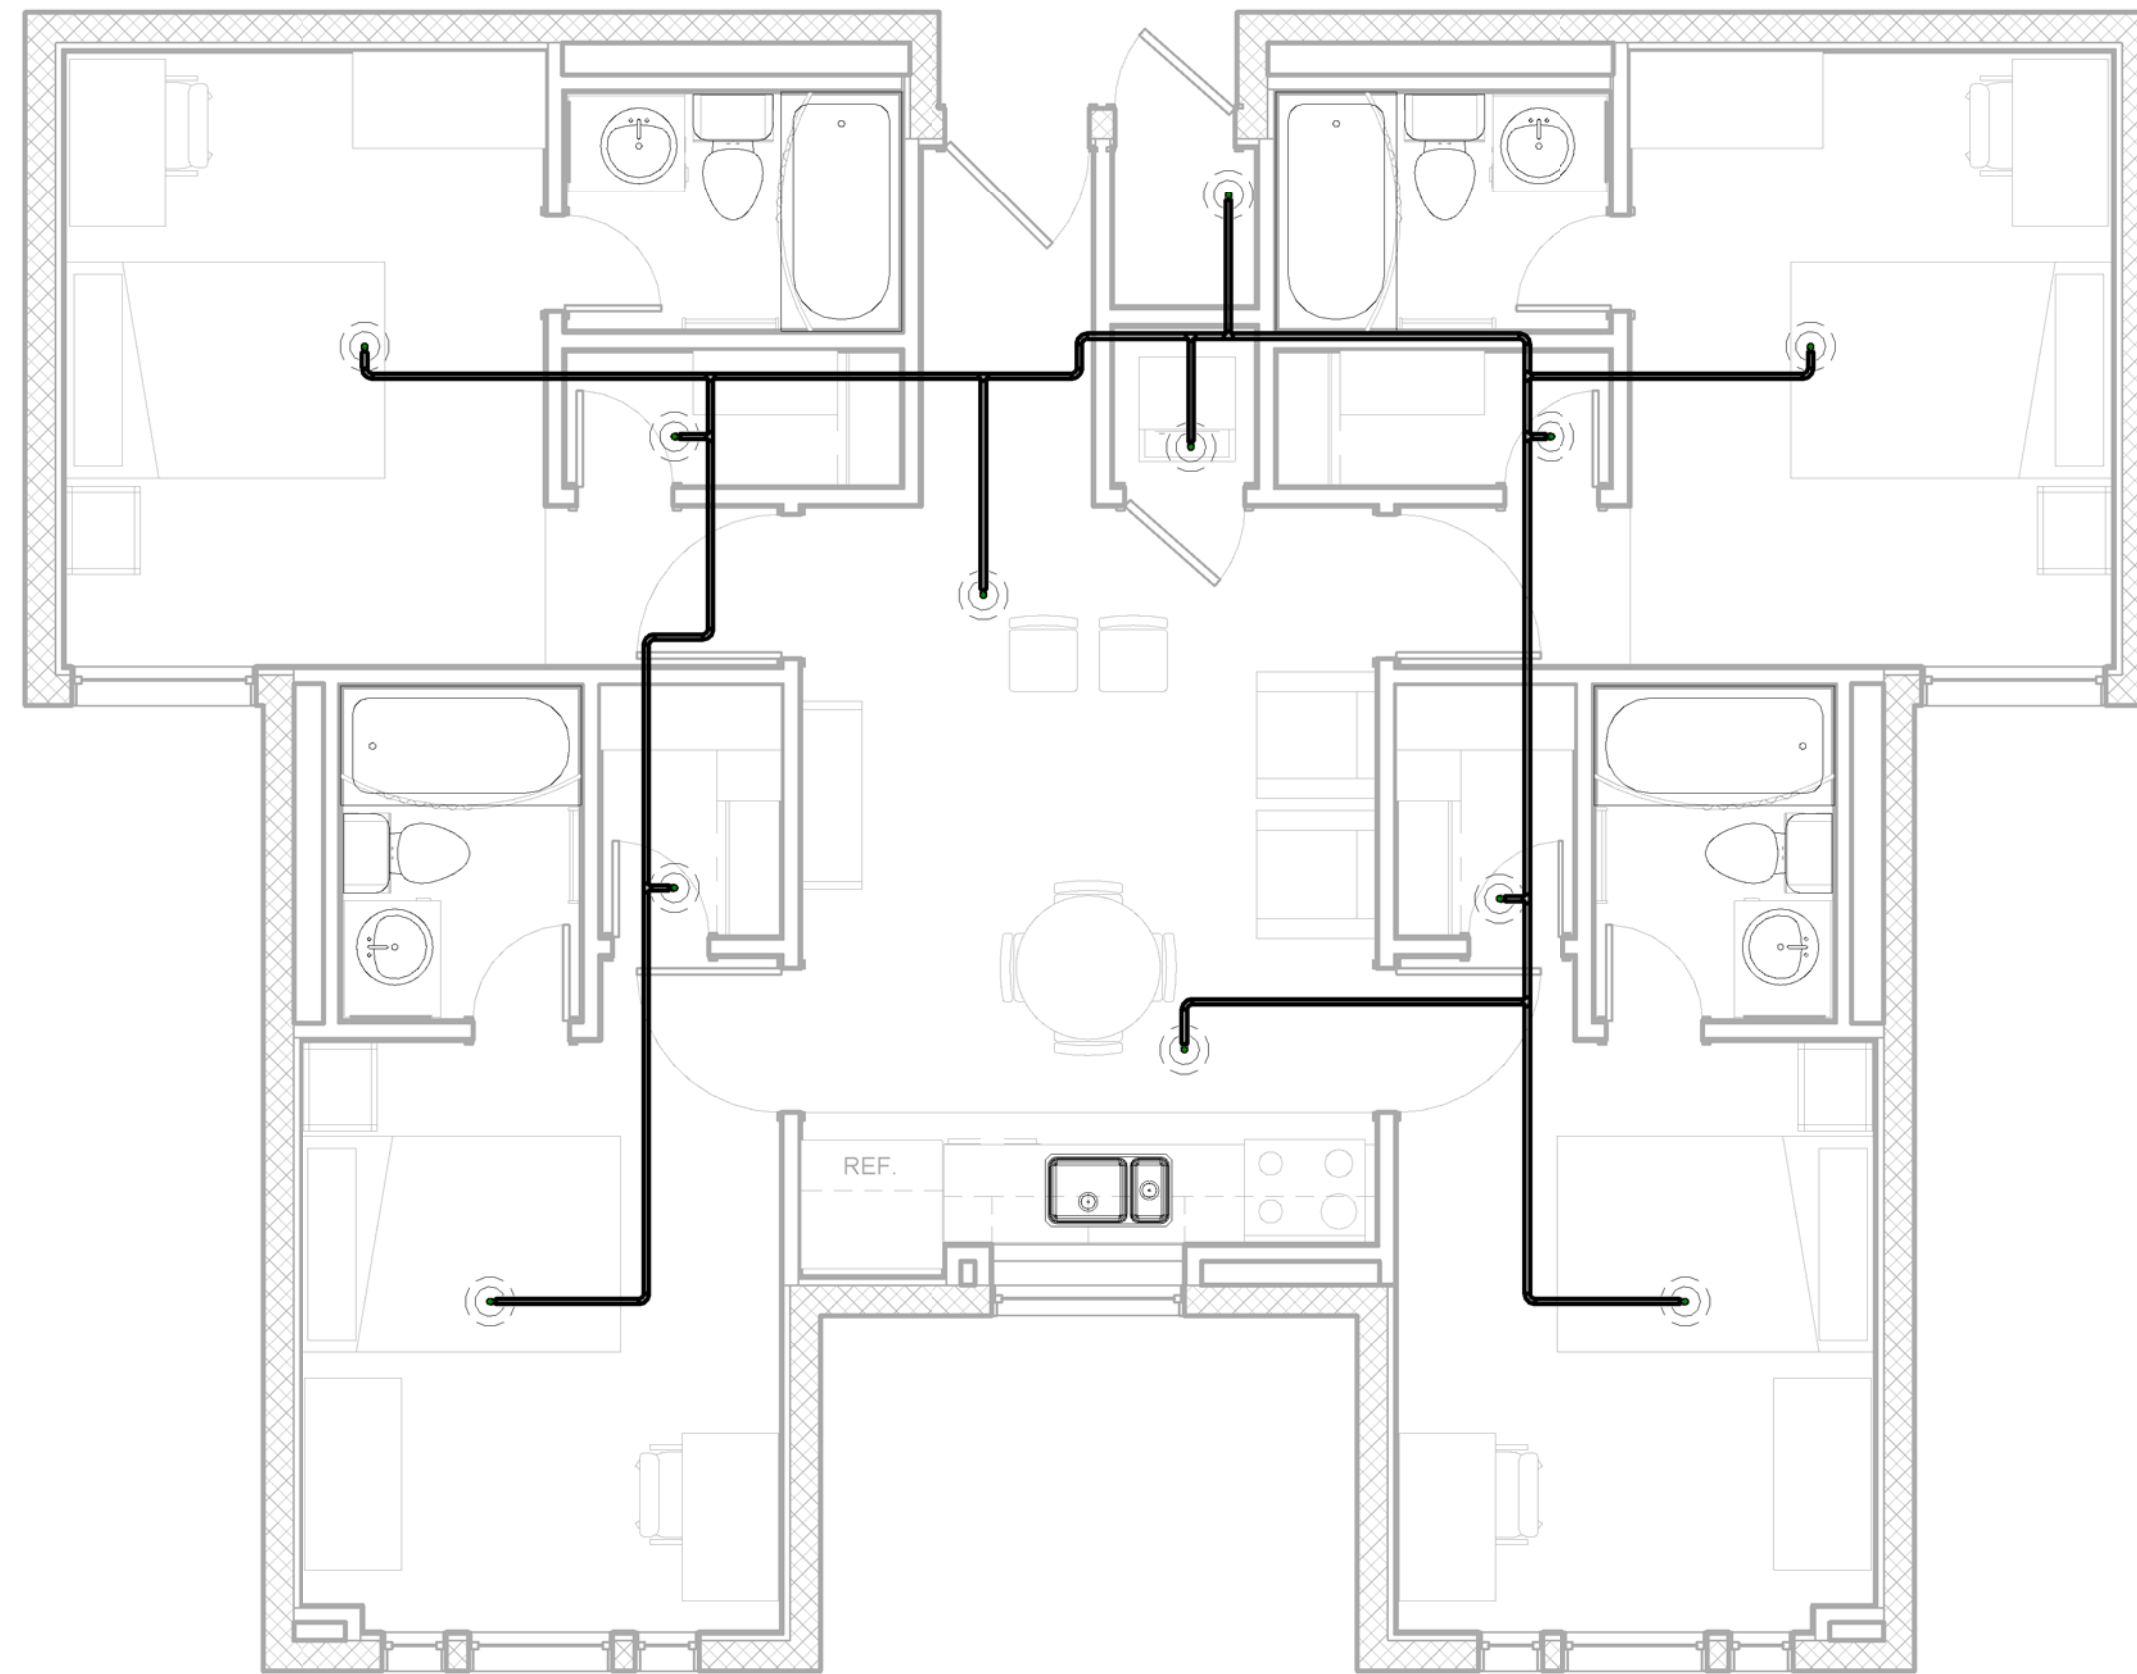

① 1 - FIRE PROTECTION A
1/4" = 1'-0"

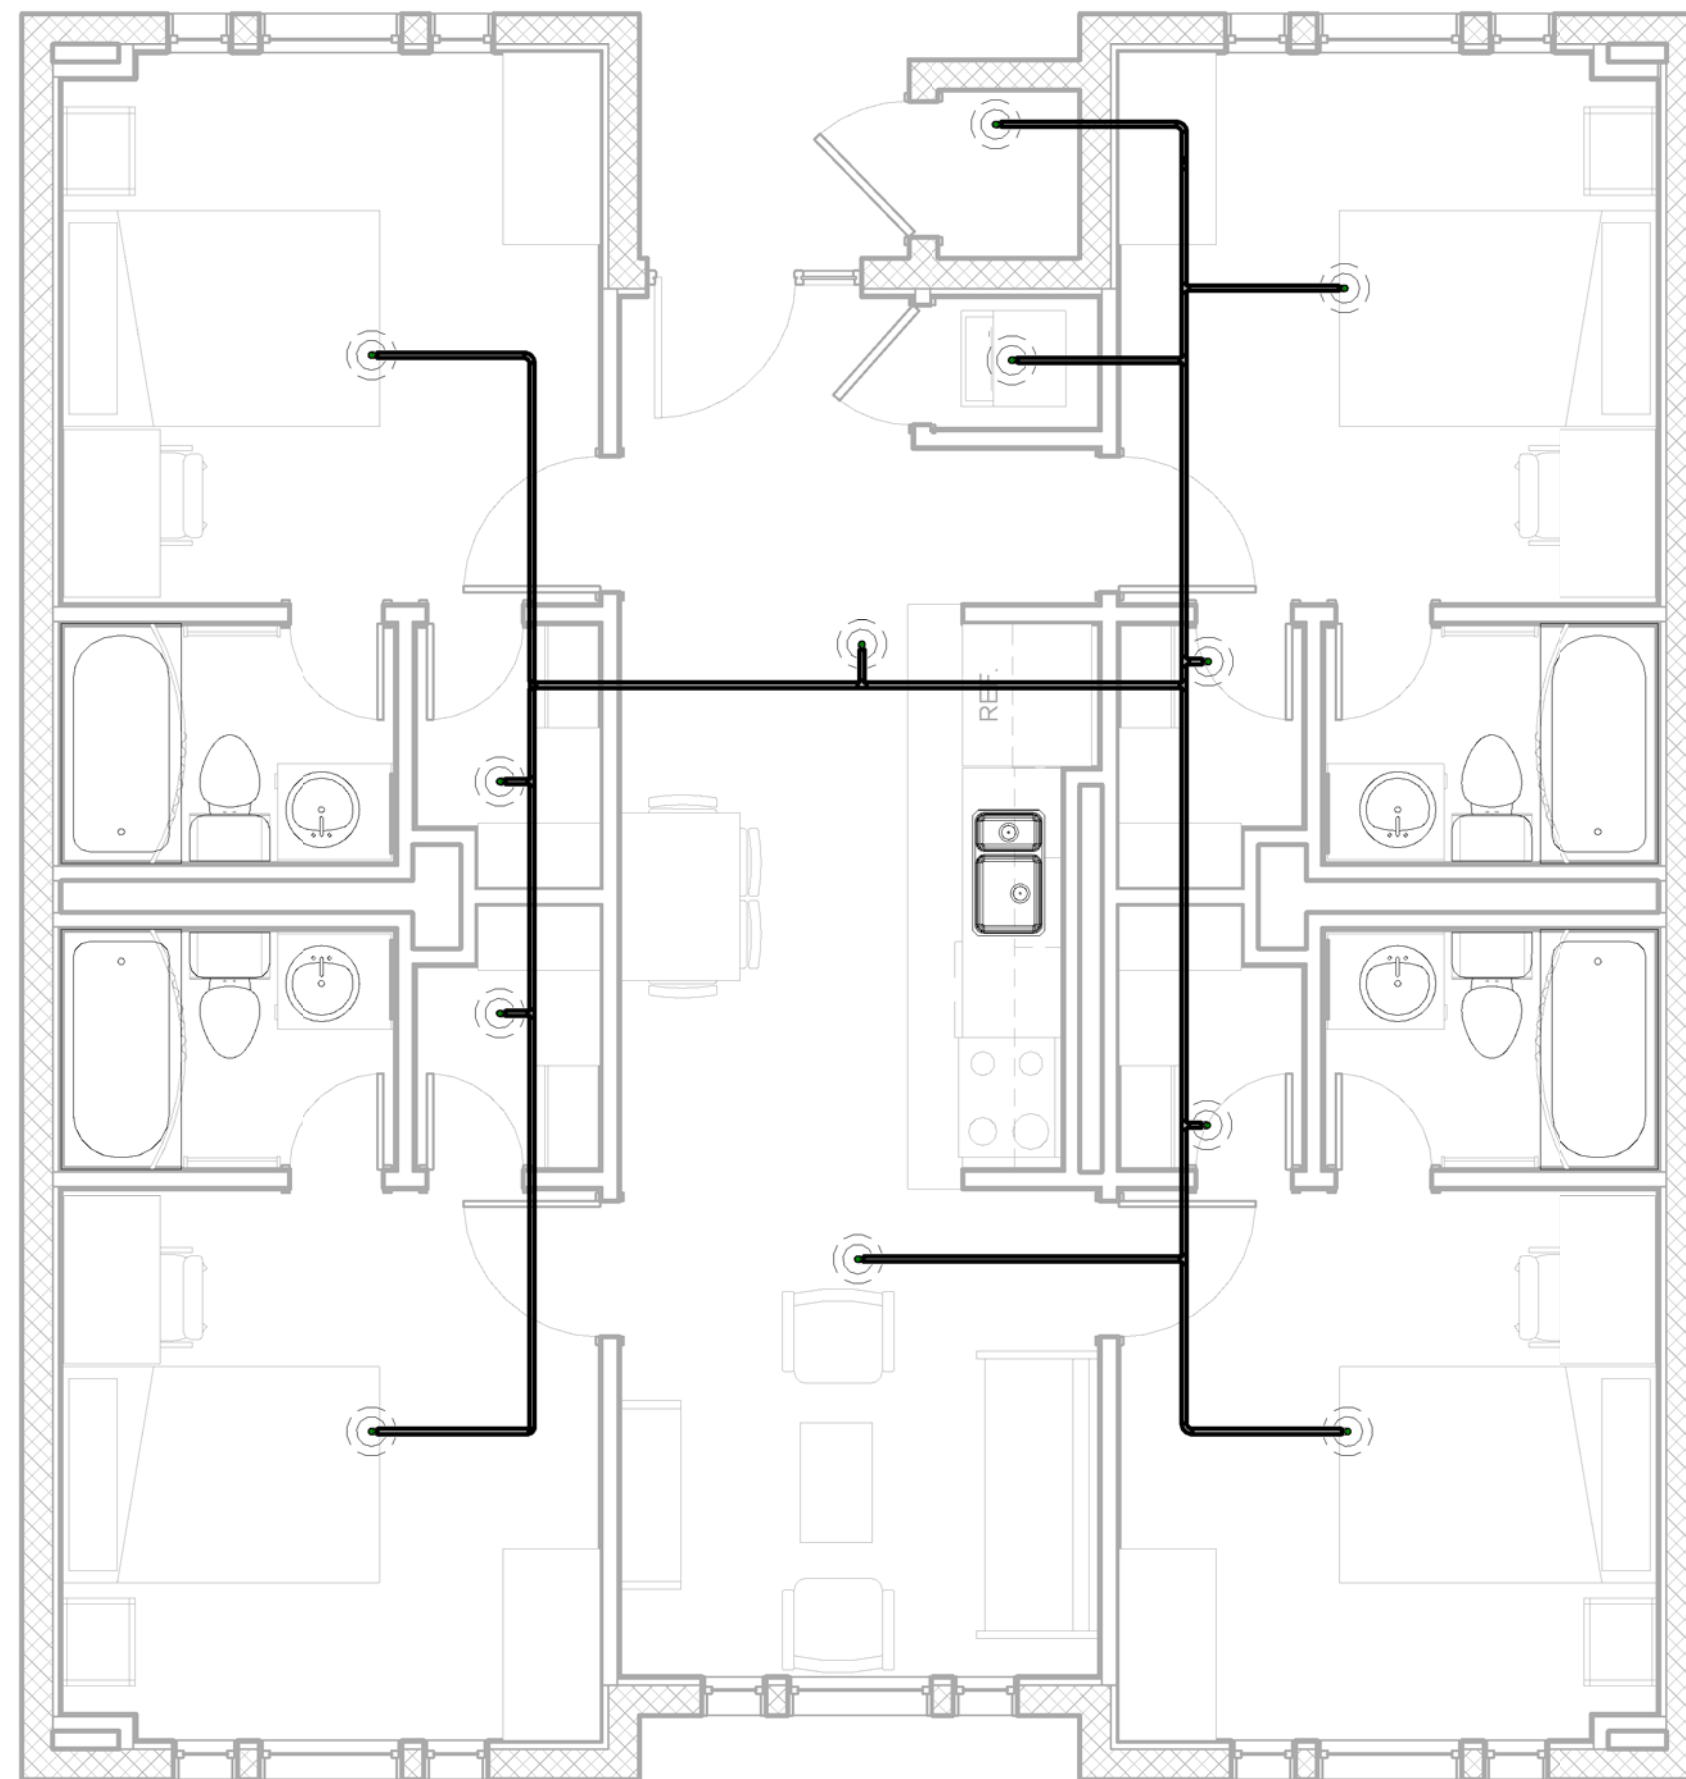


② 1 - FIRE PROTECTION B
1/4" = 1'-0"

D


C

B

A

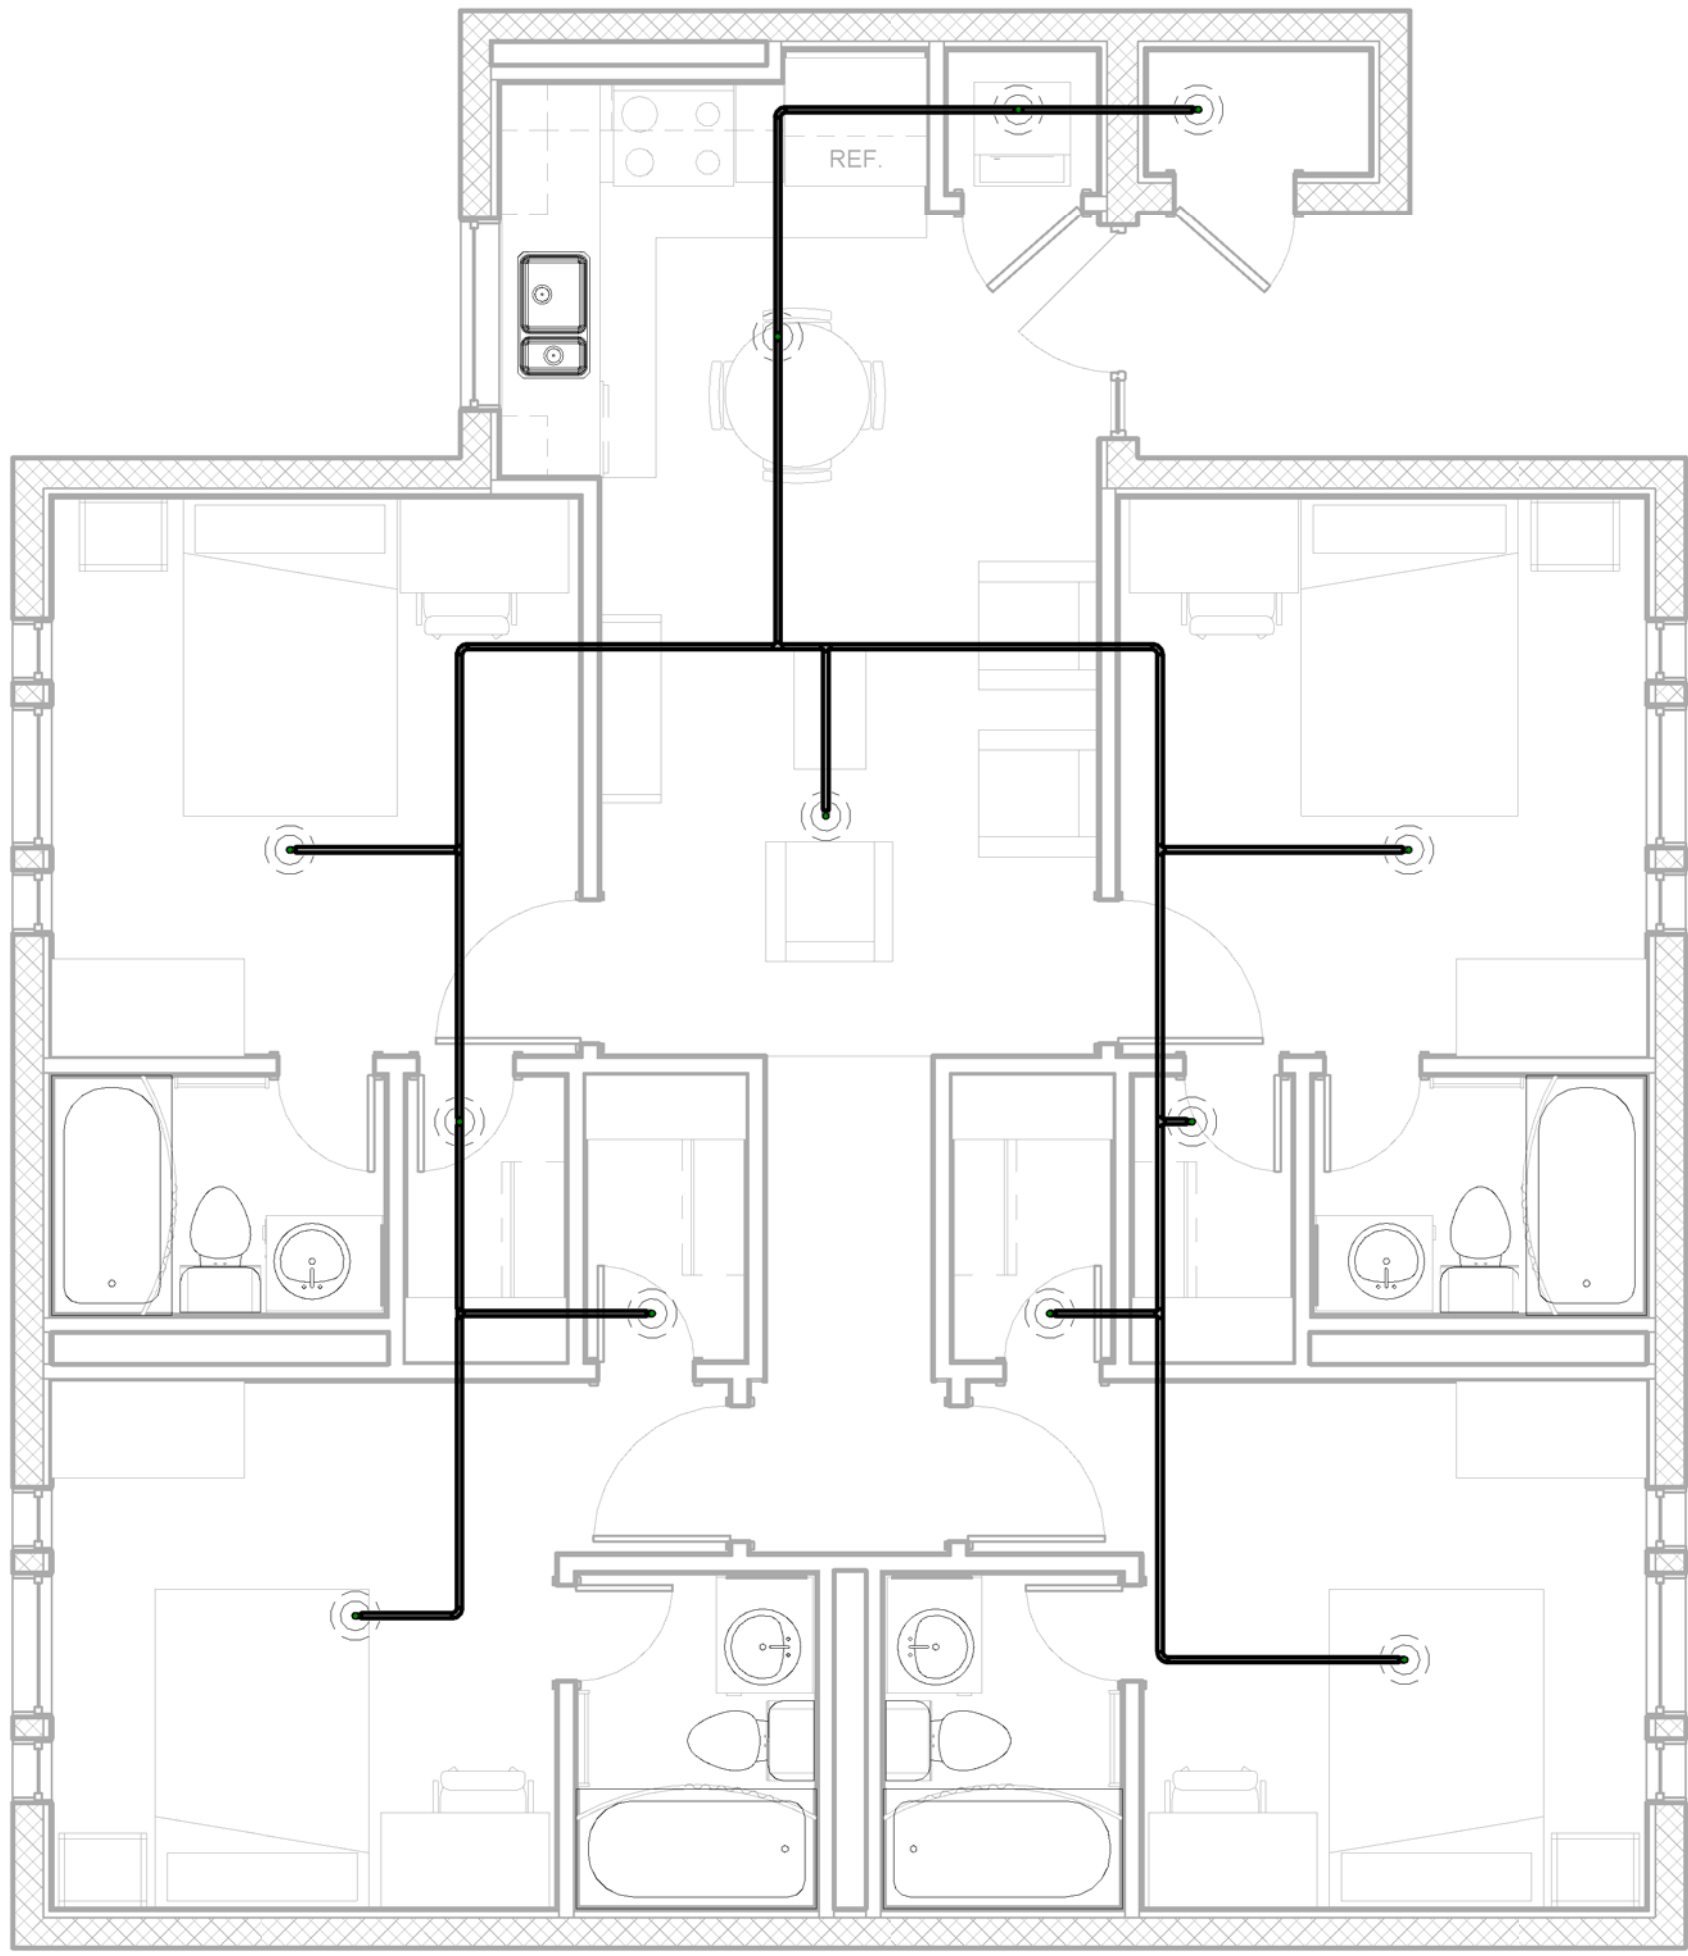

① 1 - FIRE PROTECTION C
1/4" = 1'-0"

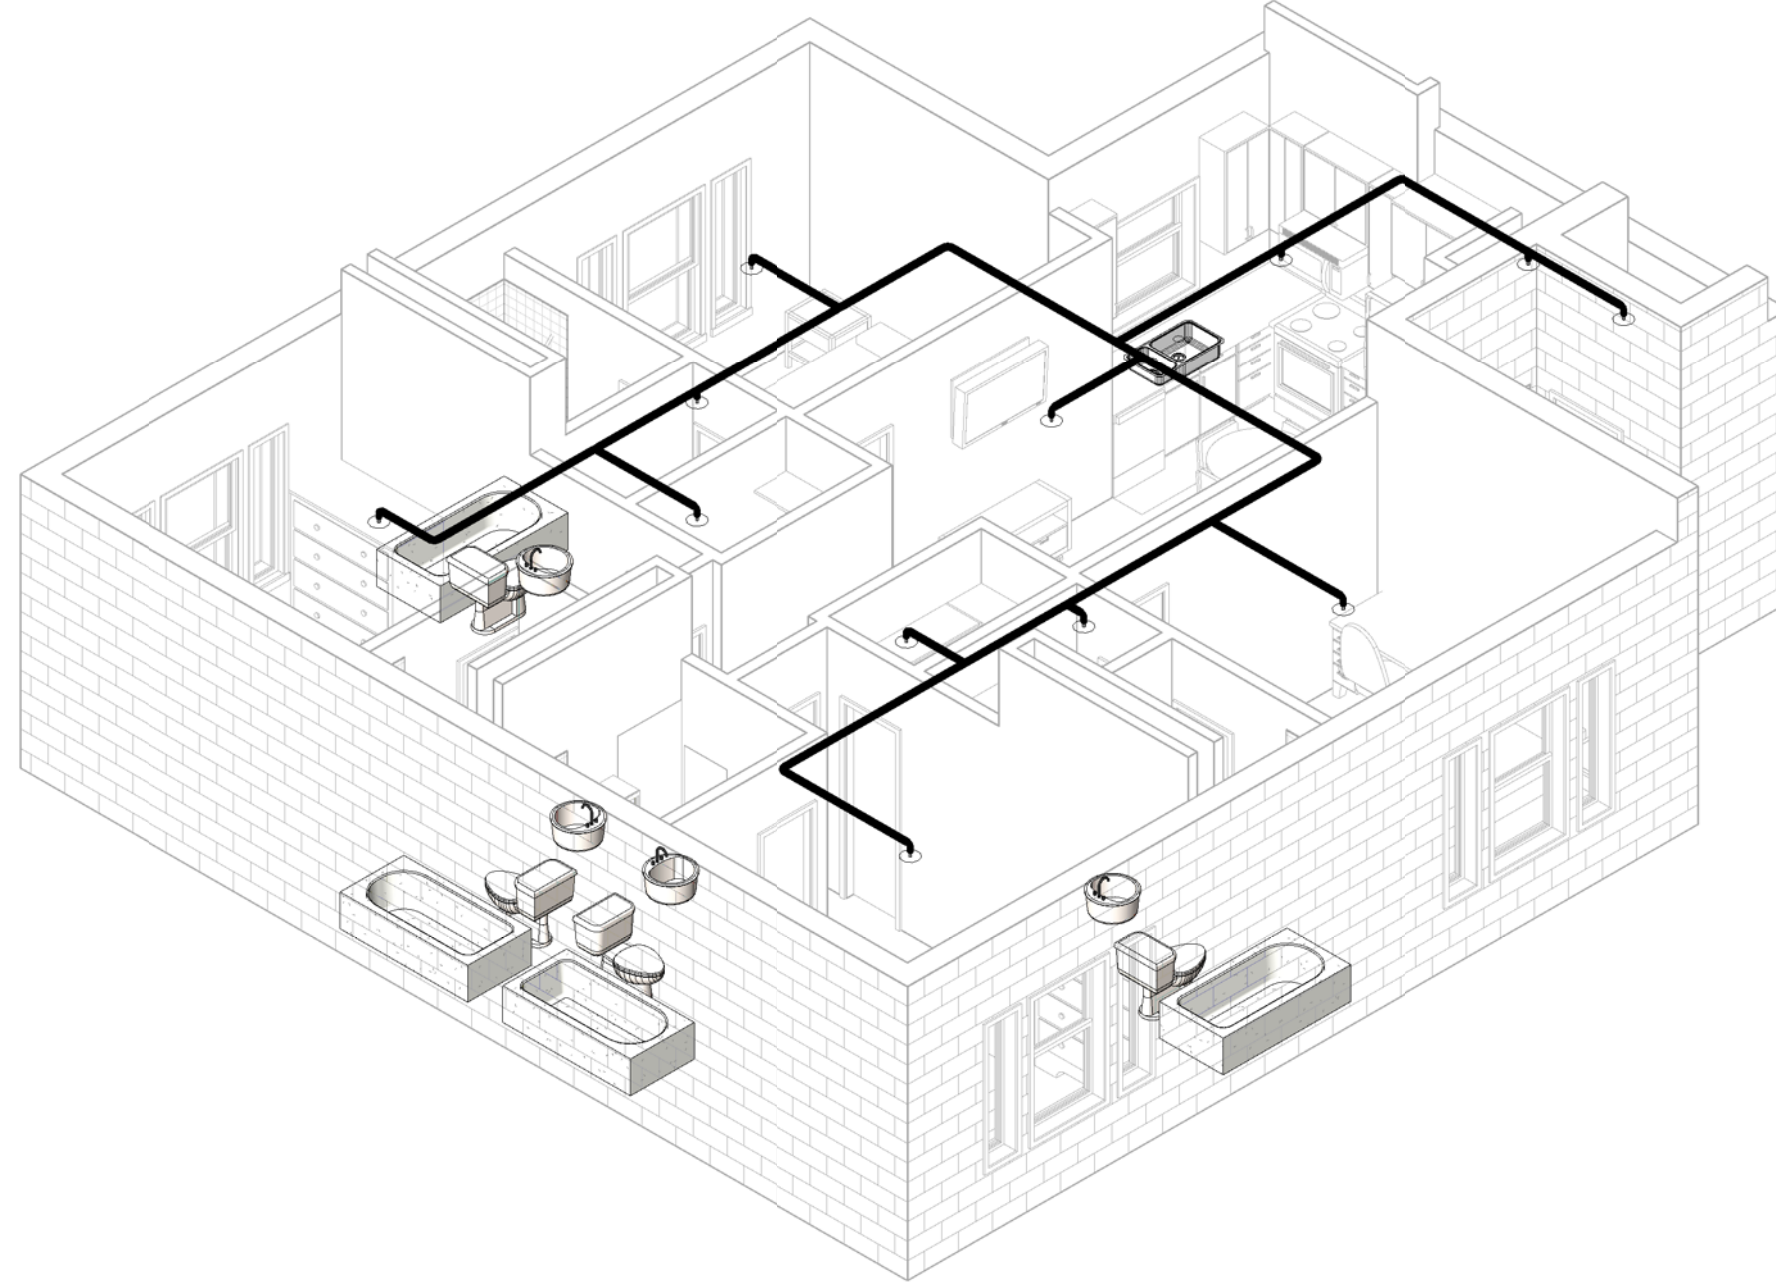

② 3D FIRE PROTECTION C

